

A. FOR SYMBOLS, ABBREVIATIONS AND GENERAL NOTES SEE DRAWING E001.

B. FOR OVERALL FIRST FLOOR LIGHTING PLAN - NEW WORK, SEE DRAWING E201L.

C. FOR POWER RISER DIAGRAM, PANEL AND LIGHTING FIXTURE SCHEDULES, SEE DRAWING E501.

1. PROVIDE NEW LIGHTING FIXTURE INCLUDING WIRING AND CONDUIT AS SHOWN. FOR EXACT LOCATION AND MOUNTING HEIGHT OF THE LIGHTING FIXTURE, SEE ARCHITECTURAL DRAWINGS.
2. PROVIDE NEW LIGHTING FIXTURE INCLUDING WIRING AS SHOWN. CONNECT LIGHTING FIXTURE TO NEAREST EXISTING CIRCUIT.
3. PROVIDE NEW LIGHTING SWITCH INCLUDING WIRING AND CONDUIT AS SHOWN. COORDINATE WITH OWNER FOR EXACT LOCATION AND MOUNTING HEIGHT.
4. PROVIDE NEW CEILING MOUNTED OCCUPANCY SENSOR AT SHOWN, WIRED WITH WALL MOUNTED LIGHT SWITCH TO OVERRIDE THE SENSOR.
5. PROVIDE NEW EXIT AND EMERGENCY LIGHT AS SHOWN. CONNECT EXIT AND EMERGENCY LIGHT AHEAD OF THE SWITCH.
6. PROVIDE NEW CEILING MOUNTED DAY LIGHT SENSOR WITH ON/OFF PHOTOCELL CONTROL AND AUTOMATIC DAYLIGHT HARVESTING/DIMMING CONTROL. THE SENSORS SHALL BE POWERED FROM SAME LIGHTING CIRCUIT AND COMMUNICATE WITH ALL LIGHTING FIXTURES CONSIDERED IN THE ZONE. PROVIDE RELAY/COMING PACKS AS REQUIRED TO ENABLE CONTROL OF FIXTURES INDIVIDUALLY OR IN GROUPS. THE DAY LIGHT SENSORS SHALL BE WIRED WITH WALL MOUNTED LIGHT SWITCH TO OVER RIDE THE DAY LIGHT SAVING FUNCTION.
7. PROVIDE NEW EXTERIOR LIGHTING FIXTURE INCLUDING WIRING AND CONDUIT AS SHOWN. FOR EXACT LOCATION AND MOUNTING HEIGHT OF THE LIGHTING FIXTURE, SEE ARCHITECTURAL DRAWINGS. FOR LIGHTING SWITCH LOCATION, COORDINATE WITH OWNER.

Shinberg Levinas 5101 Wisconsin Ave #310 T 202.244.5101
Architectural Design Inc. Washington, DC 20016 F 202.244.5363

© Copyright 2020 Steinberg/Levinus Architectural Design Inc.

12200 SCAGGSVILLE ROAD
FULTON, MARYLAND 20759

TEMPLE ISAIAH
1200 SCAGGSVILLE ROAD
FULTON, MD 20759
(301) 317-1101

DEVELOPMENT MANAGEMENT GROUP, LLC
5054 DORSEY HALL DRIVE, SUITE 204
ELLICOTT CITY, MD 21042
(410) 884-5393

FSH ASSOCIATES LLC
6339 HOWARD LANE
ELKRIDGE, MD, 21075
(410) 567-5200


KPFF
2000 M STREET, NW, SUITE 750-F
WASHINGTON, DC 20036
(502) 325-0100

FRIEDMAN ENGINEERING
11709 FULHAM STREET
SILVER SPRING, MD 20902
(301) 298-5070

ASTUTE ENGINEERING
8450 TYCO ROAD, SUITE D
VIENNA, VA 22182
(202) 400-2004


ACOUSTIC 2
6208 WICASSET ROAD
BETHESDA, MD 20816
(202) 244-4546

 SAGE STUDIO DESIGN & PLANNING
3340 NORTHAMPTON STREET, NW
WASHINGTON, DC 20015
(202) 460-1662

[illegible]

SCALE: $1/4" = 1'$

E201LA

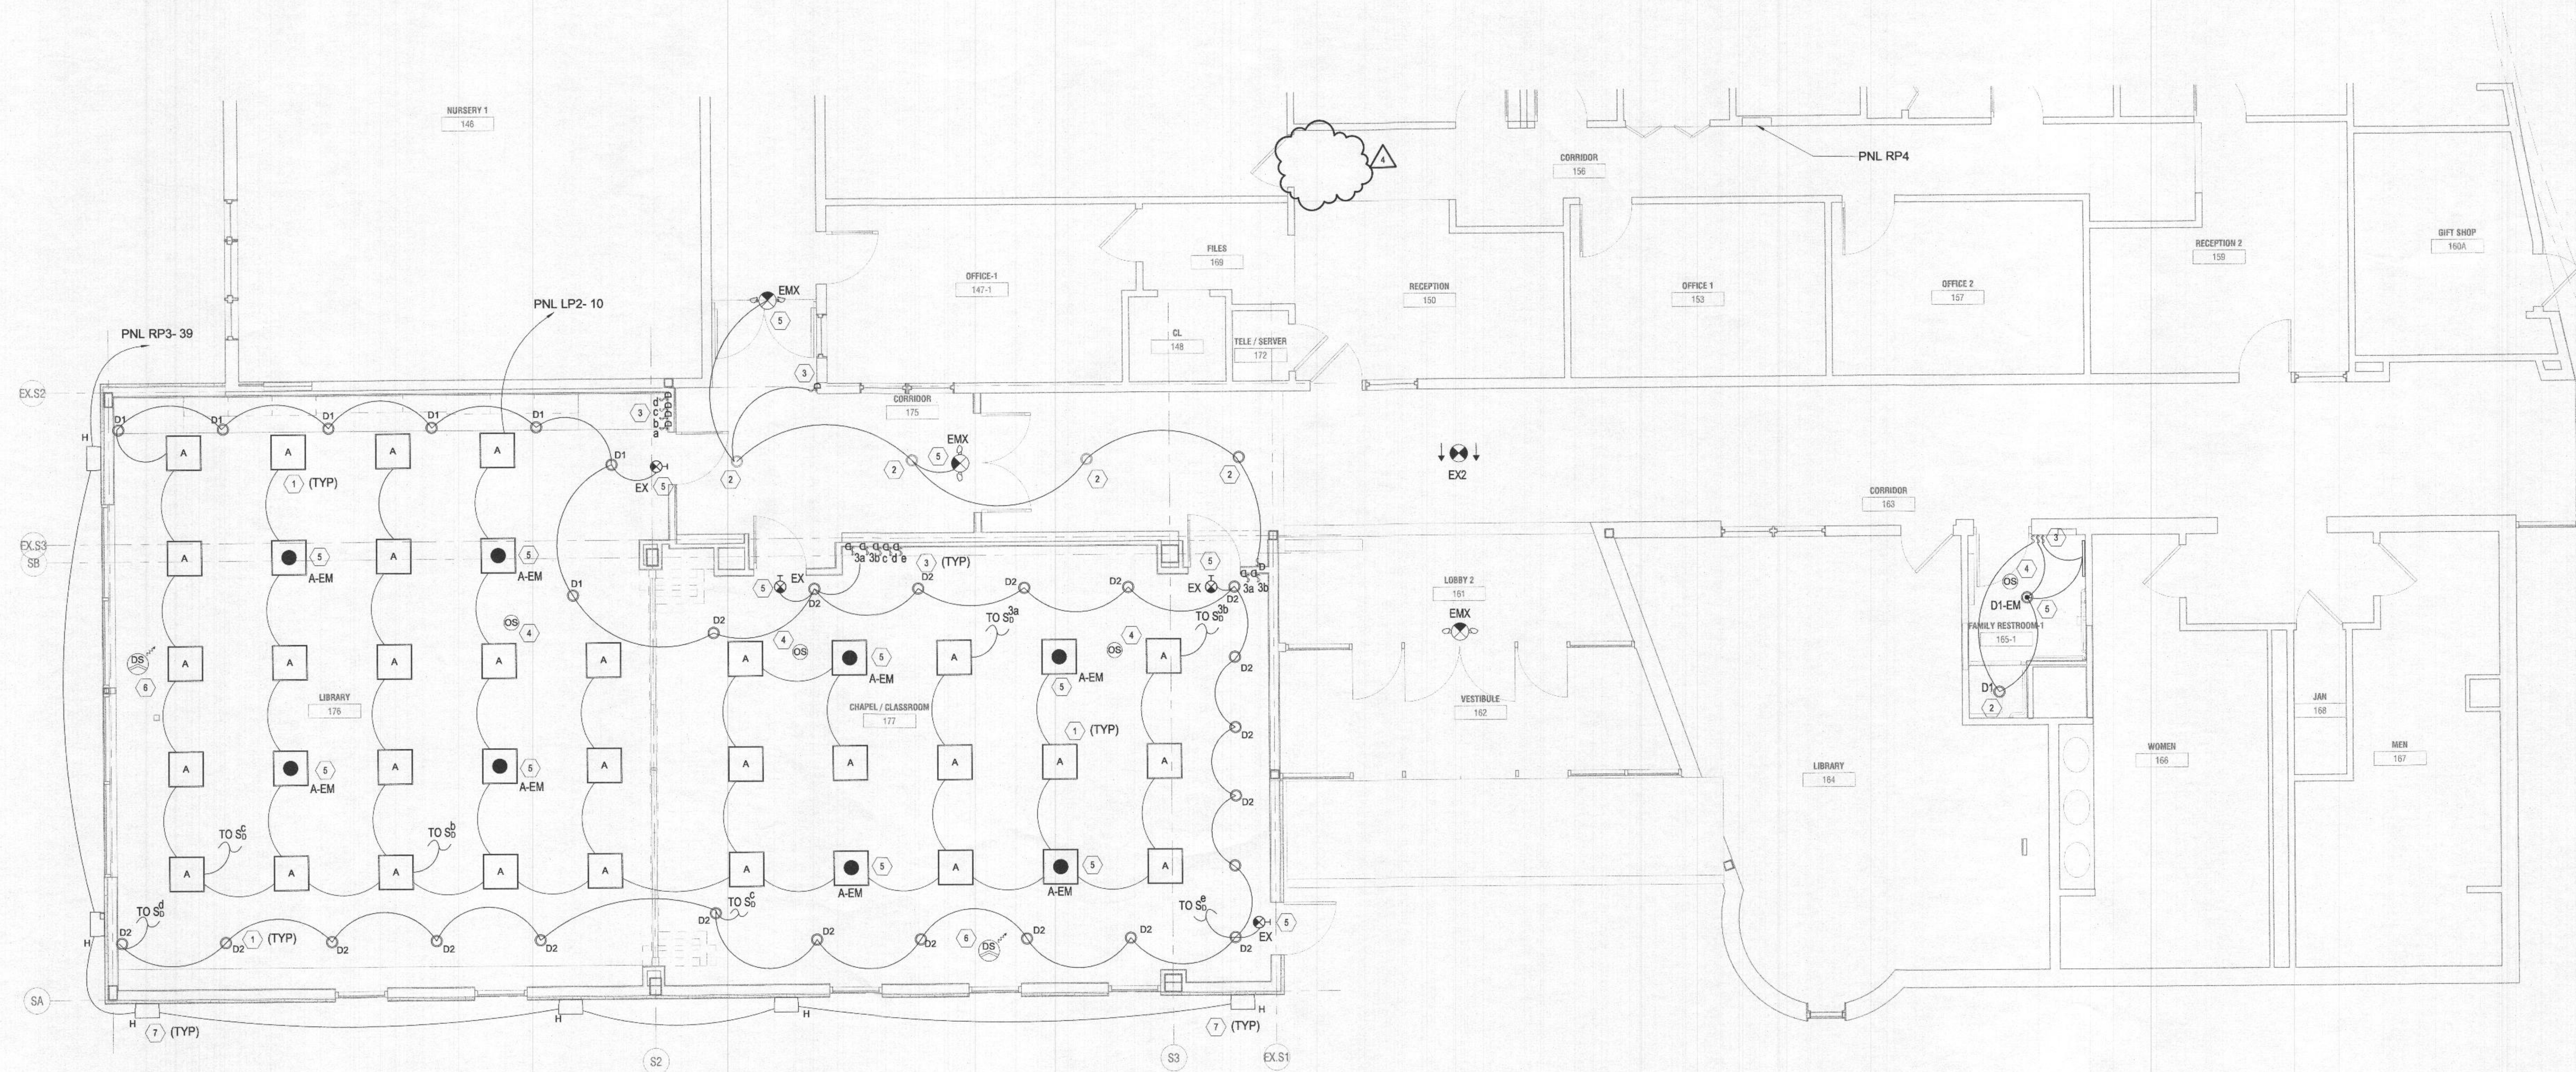

1 ELECTRICAL FIRST FLOOR LIGHTING PLAN - PART A
1/4" = 1'-0"

2 KEY PLAN
NOT TO SCALE

A. FOR SYMBOLS, ABBREVIATIONS AND GENERAL NOTES SEE DRAWING E001.

B. FOR OVERALL FIRST FLOOR LIGHTING PLAN - NEW WORK, SEE DRAWING E201L.

C. FOR POWER RISER DIAGRAM, PANEL AND LIGHTING FIXTURE SCHEDULES, SEE DRAWING E501.

1. PROVIDE NEW LIGHTING FIXTURE INCLUDING WIRING AND CONDUIT AS SHOWN. FOR EXACT LOCATION AND MOUNTING HEIGHT OF THE LIGHTING FIXTURE, SEE ARCHITECTURAL DRAWINGS.
2. PROVIDE NEW LIGHTING SWITCH INCLUDING WIRING AND CONDUIT AS SHOWN. COORDINATE WITH OWNER FOR EXACT LOCATION AND MOUNTING HEIGHT.
3. PROVIDE NEW LIGHTING FIXTURE INCLUDING WIRING AS SHOWN. CONNECT LIGHTING FIXTURE TO NEAREST EXISTING CIRCUIT.
4. PROVIDE NEW EXIT AND EMERGENCY LIGHT AS SHOWN. CONNECT EXIT AND EMERGENCY LIGHT AHEAD OF THE SWITCH.
5. EXISTING LIGHTING FIXTURE TO REMAIN IN-PLACE DURING CONSTRUCTION.

Shinberg Levinas 5101 Wisconsin Ave #310 T 202.244.5101
Architectural Design Inc. Washington, DC 20016 F 202.244.5363

Designs and drawings are protected by copyright, and may not be reused, copied or reproduced without the expressed written consent of the entity above.

© Copyright 2020 ShinbergLevinas Architectural Design Inc.
All rights reserved worldwide

12200 SCAGGSVILLE ROAD
FULTON, MARYLAND 20759

OWNER

TEMPLE ISAIAH
1200 SCAGGSVILLE ROAD
FULTON, MD 20759
(301) 317-1101

OWNER'S REPRESENTATIVE
DEVELOPMENT MANAGEMENT GROUP, LLC
5054 DORSEY HALL DRIVE, SUITE 204
ELLCOT CITY, MD 21042
(410) 884-5393

CIVIL ENGINEER
FSH ASSOCIATES LLC
6339 HOWARD LANE
ELK RIDGE, MD, 21075
(410) 567-5200

STRUCTURAL ENGINEER
KPFF
2000 M STREET, NW, SUITE 750-F
WASHINGTON, DC 20036
(502) 325-0100

M/P ENGINEER & FIRE SAFETY

FRIEDMAN ENGINEERING
11709 FULHAM STREET
SILVER SPRING, MD 20902
(301) 298-5070

ELECTRICAL ENGINEER

ASTUTE ENGINEERING
8450 TYCO ROAD, SUITE D
VIENNA, VA 22182
(202) 400-2004

ACOUSTIC CONSULTANT

ACOUSTIC 2
6208 WICASSET ROAD
BETHESDA, MD 20816
(202) 244-4646

LANDSCAPE CONSULTANT

SAGE STUDIO DESIGN & PLANNING
3340 NORTHAMPTON STREET, NW
WASHINGTON, DC 20015
(202) 460-1662

ISSUES

NO.	ISSUE	DATE
	100% CONSTRUCTION DOCUMENTS	01.15.2021
	PERMIT SET	12.07.2021
1	PERMIT COMMENTS 1	01.21.2022
3	PERMIT REVISION 3	04.01.2022
4	PERMIT REVISION 4	04.29.2022

SEAL




PROFESSIONAL CERTIFICATION: I HEREBY CERTIFY THAT THESE DOCUMENTS
WERE PREPARED OR APPROVED BY ME, AND THAT I AM A LICENSED PROFESSIONAL
ENGINEER UNDER THE LAWS OF THE STATE OF MARYLAND.
LICENSE NO: 45883 EXPIRATION DATE: 03/24/2024

DATE: 04/29/2022

SCALE: $1/4" = 1'-0"$

ELECTRICAL FIRST
FLOOR LIGHTING PLAN
PART B

E201LB

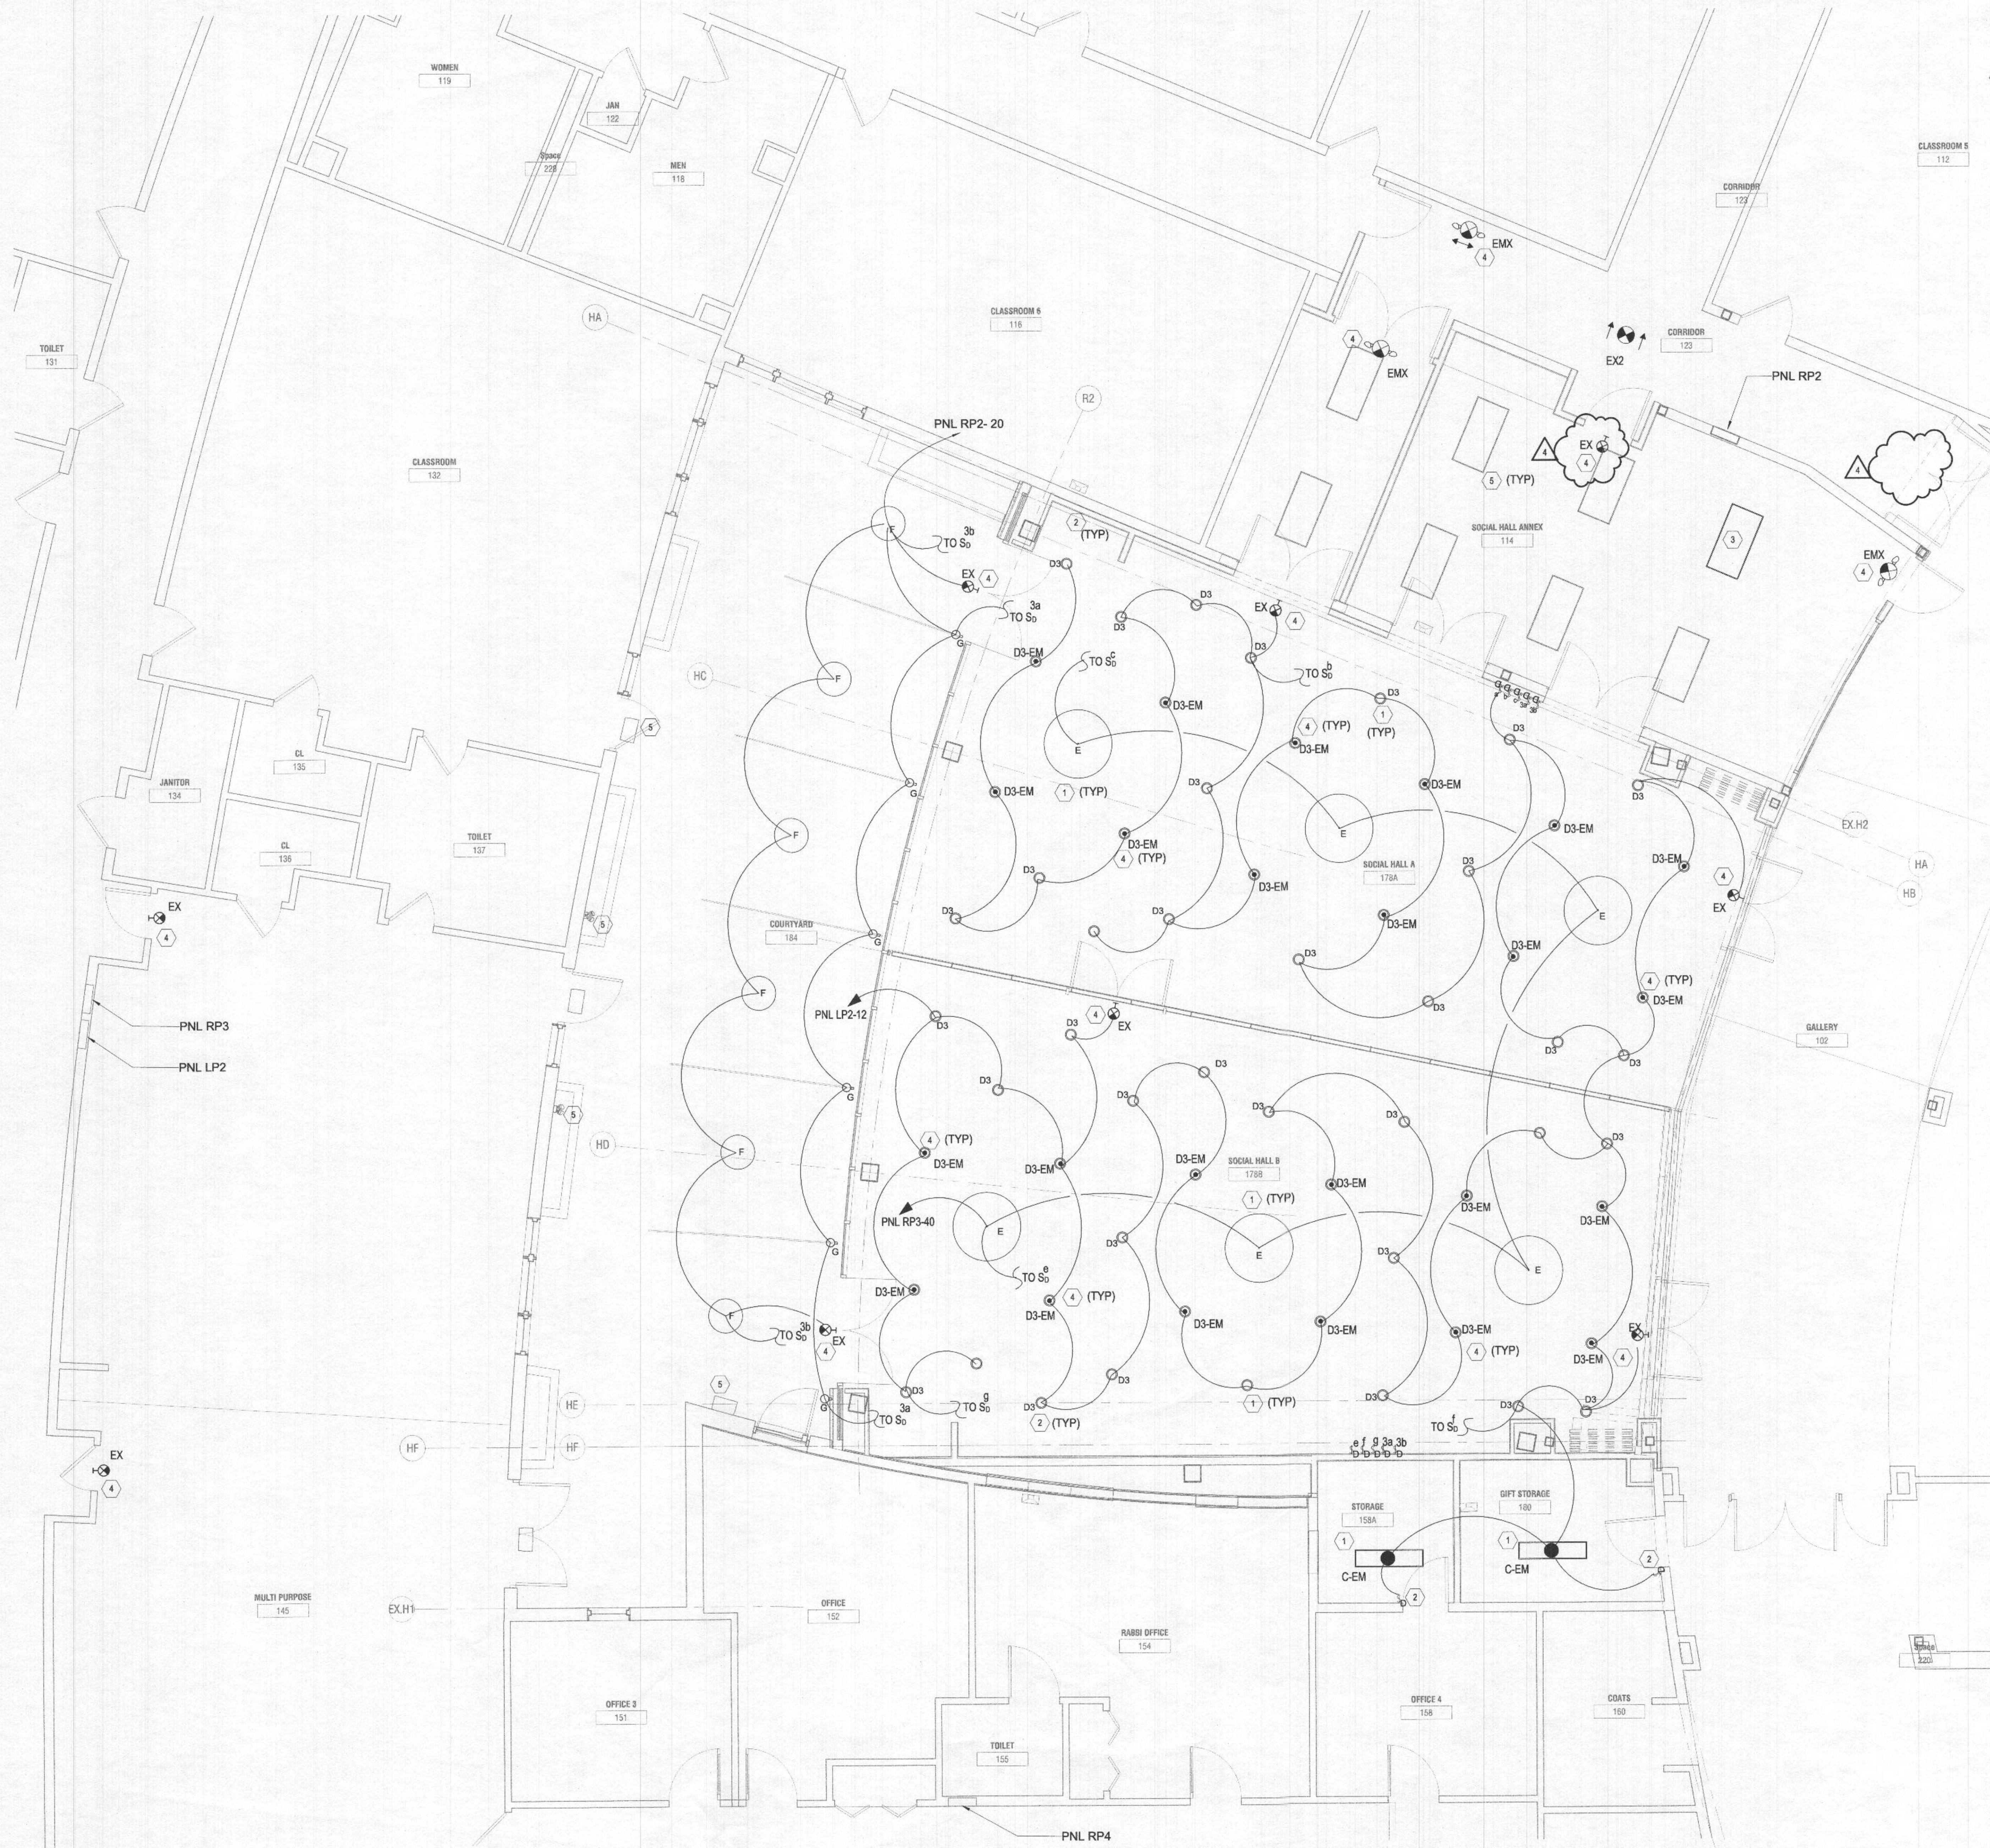

① ELECTRICAL FIRST FLOOR LIGHTING PLAN - PART B
1/4" = 1'-0"

2 KEY PLAN
NOT TO SCALE

1. PROVIDE NEW LIGHTING FIXTURE INCLUDING WIRING AND CONDUIT AS SHOWN. FOR EXACT LOCATION AND MOUNTING HEIGHT OF THE LIGHTING FIXTURE, SEE ARCHITECTURAL DRAWINGS.
2. PROVIDE NEW LIGHTING SWITCH INCLUDING WIRING AND CONDUIT AS SHOWN. COORDINATE WITH OWNER FOR EXACT LOCATION AND MOUNTING HEIGHT.
3. PROVIDE NEW EXIT AND EMERGENCY LIGHT AS SHOWN. CONNECT EXIT AND EMERGENCY LIGHT AHEAD OF THE SWITCH.
4. EXISTING LIGHTING FIXTURE TO REMAIN IN-PLACE DURING CONSTRUCTION.
5. EXISTING RELOCATED PHOTOCELL.
6. PROVIDE NEW EXTERIOR LIGHTING FIXTURE INCLUDING WIRING AND CONDUIT AS SHOWN. FOR EXACT LOCATION AND MOUNTING HEIGHT OF THE LIGHTING FIXTURE, SEE ARCHITECTURAL DRAWINGS. FOR LIGHTING SWITCH LOCATION, COORDINATE WITH OWNER.
7. PROVIDE NEW WALL MOUNTED MOTION SENSOR AS SHOWN INCLUDING WIRING AND CONDUIT.

- A. FOR SYMBOLS, ABBREVIATIONS AND GENERAL NOTES SEE DRAWING E001.
- B. FOR OVERALL FIRST FLOOR LIGHTING PLAN - NEW WORK, SEE DRAWING E201L.
- C. FOR POWER RISER DIAGRAM, PANEL AND LIGHTING FIXTURE SCHEDULES, SEE DRAWING E501.

Shinberg Levinas 5101 Wisconsin Ave #310 T 202.244.5101
Architectural Design Inc. Washington, DC 20016 F 202.244.5363

Designs and drawings are protected by copyright, and may not be copied, copied or reproduced without the expressed written consent of the entity above.

© Copyright 2000 ShinbergLevinas Architectural Design Inc.
All rights reserved worldwide

12200 SCAGGSVILLE ROAD
FULTON, MARYLAND 20759

OWNER
TEMPLE ISAIAH
1200 SCAGGSVILLE ROAD
FULTON, MD 20759
(301) 317-1101

OWNER'S REPRESENTATIVE

DEVELOPMENT MANAGEMENT GROUP, LLC
5054 DORSEY HALL DRIVE, SUITE 204
ELLCOT CITY, MD 21042
(410) 864-5393

CIVIL ENGINEER

FSH ASSOCIATES LLC
6339 HOWARD LANE
ELKRIDGE, MD, 21075
(410) 567-5200

STRUCTURAL ENGINEER

KPFF
2000 M STREET, NW, SUITE 750-F
WASHINGTON, DC 20036
(502) 325-0100

M/P ENGINEER & FIRE SAFETY

FRIEDMAN ENGINEERING
11709 FULHAM STREET
SILVER SPRING, MD 20902
(301) 298-5070

ELECTRICAL ENGINEER

ASTUTE ENGINEERING
8450 TYCO ROAD, SUITE D
VIENNA, VA 22182
(202) 400-2004

ACOUSTIC CONSULTANT

ACOUSTIC 2
6208 WICASSET ROAD
BETHESDA, MD 20816
(202) 244-4646

LANDSCAPE CONSULTANT

SAGE STUDIO DESIGN & PLANNING
3340 NORTHAMPTON STREET, NW
WASHINGTON, DC 20015
(202) 460-1662

ISSUES

[illegible]

SEAL




PROFESSIONAL CERTIFICATION: I HEREBY CERTIFY THAT THESE DOCUMENTS WERE PREPARED OR APPROVED BY ME, AND THAT I AM A LICENSED PROFESSIONAL ENGINEER UNDER THE LAWS OF THE STATE OF MARYLAND.
LICENSE NO. 45003 EXPIRATION DATE: 06/30/2014

DATE: 04/29/2022

SCALE: $1/4" = 1'-0"$

ELECTRICAL FIRST
FLOOR LIGHTING PLAN -
PART C

E201LC

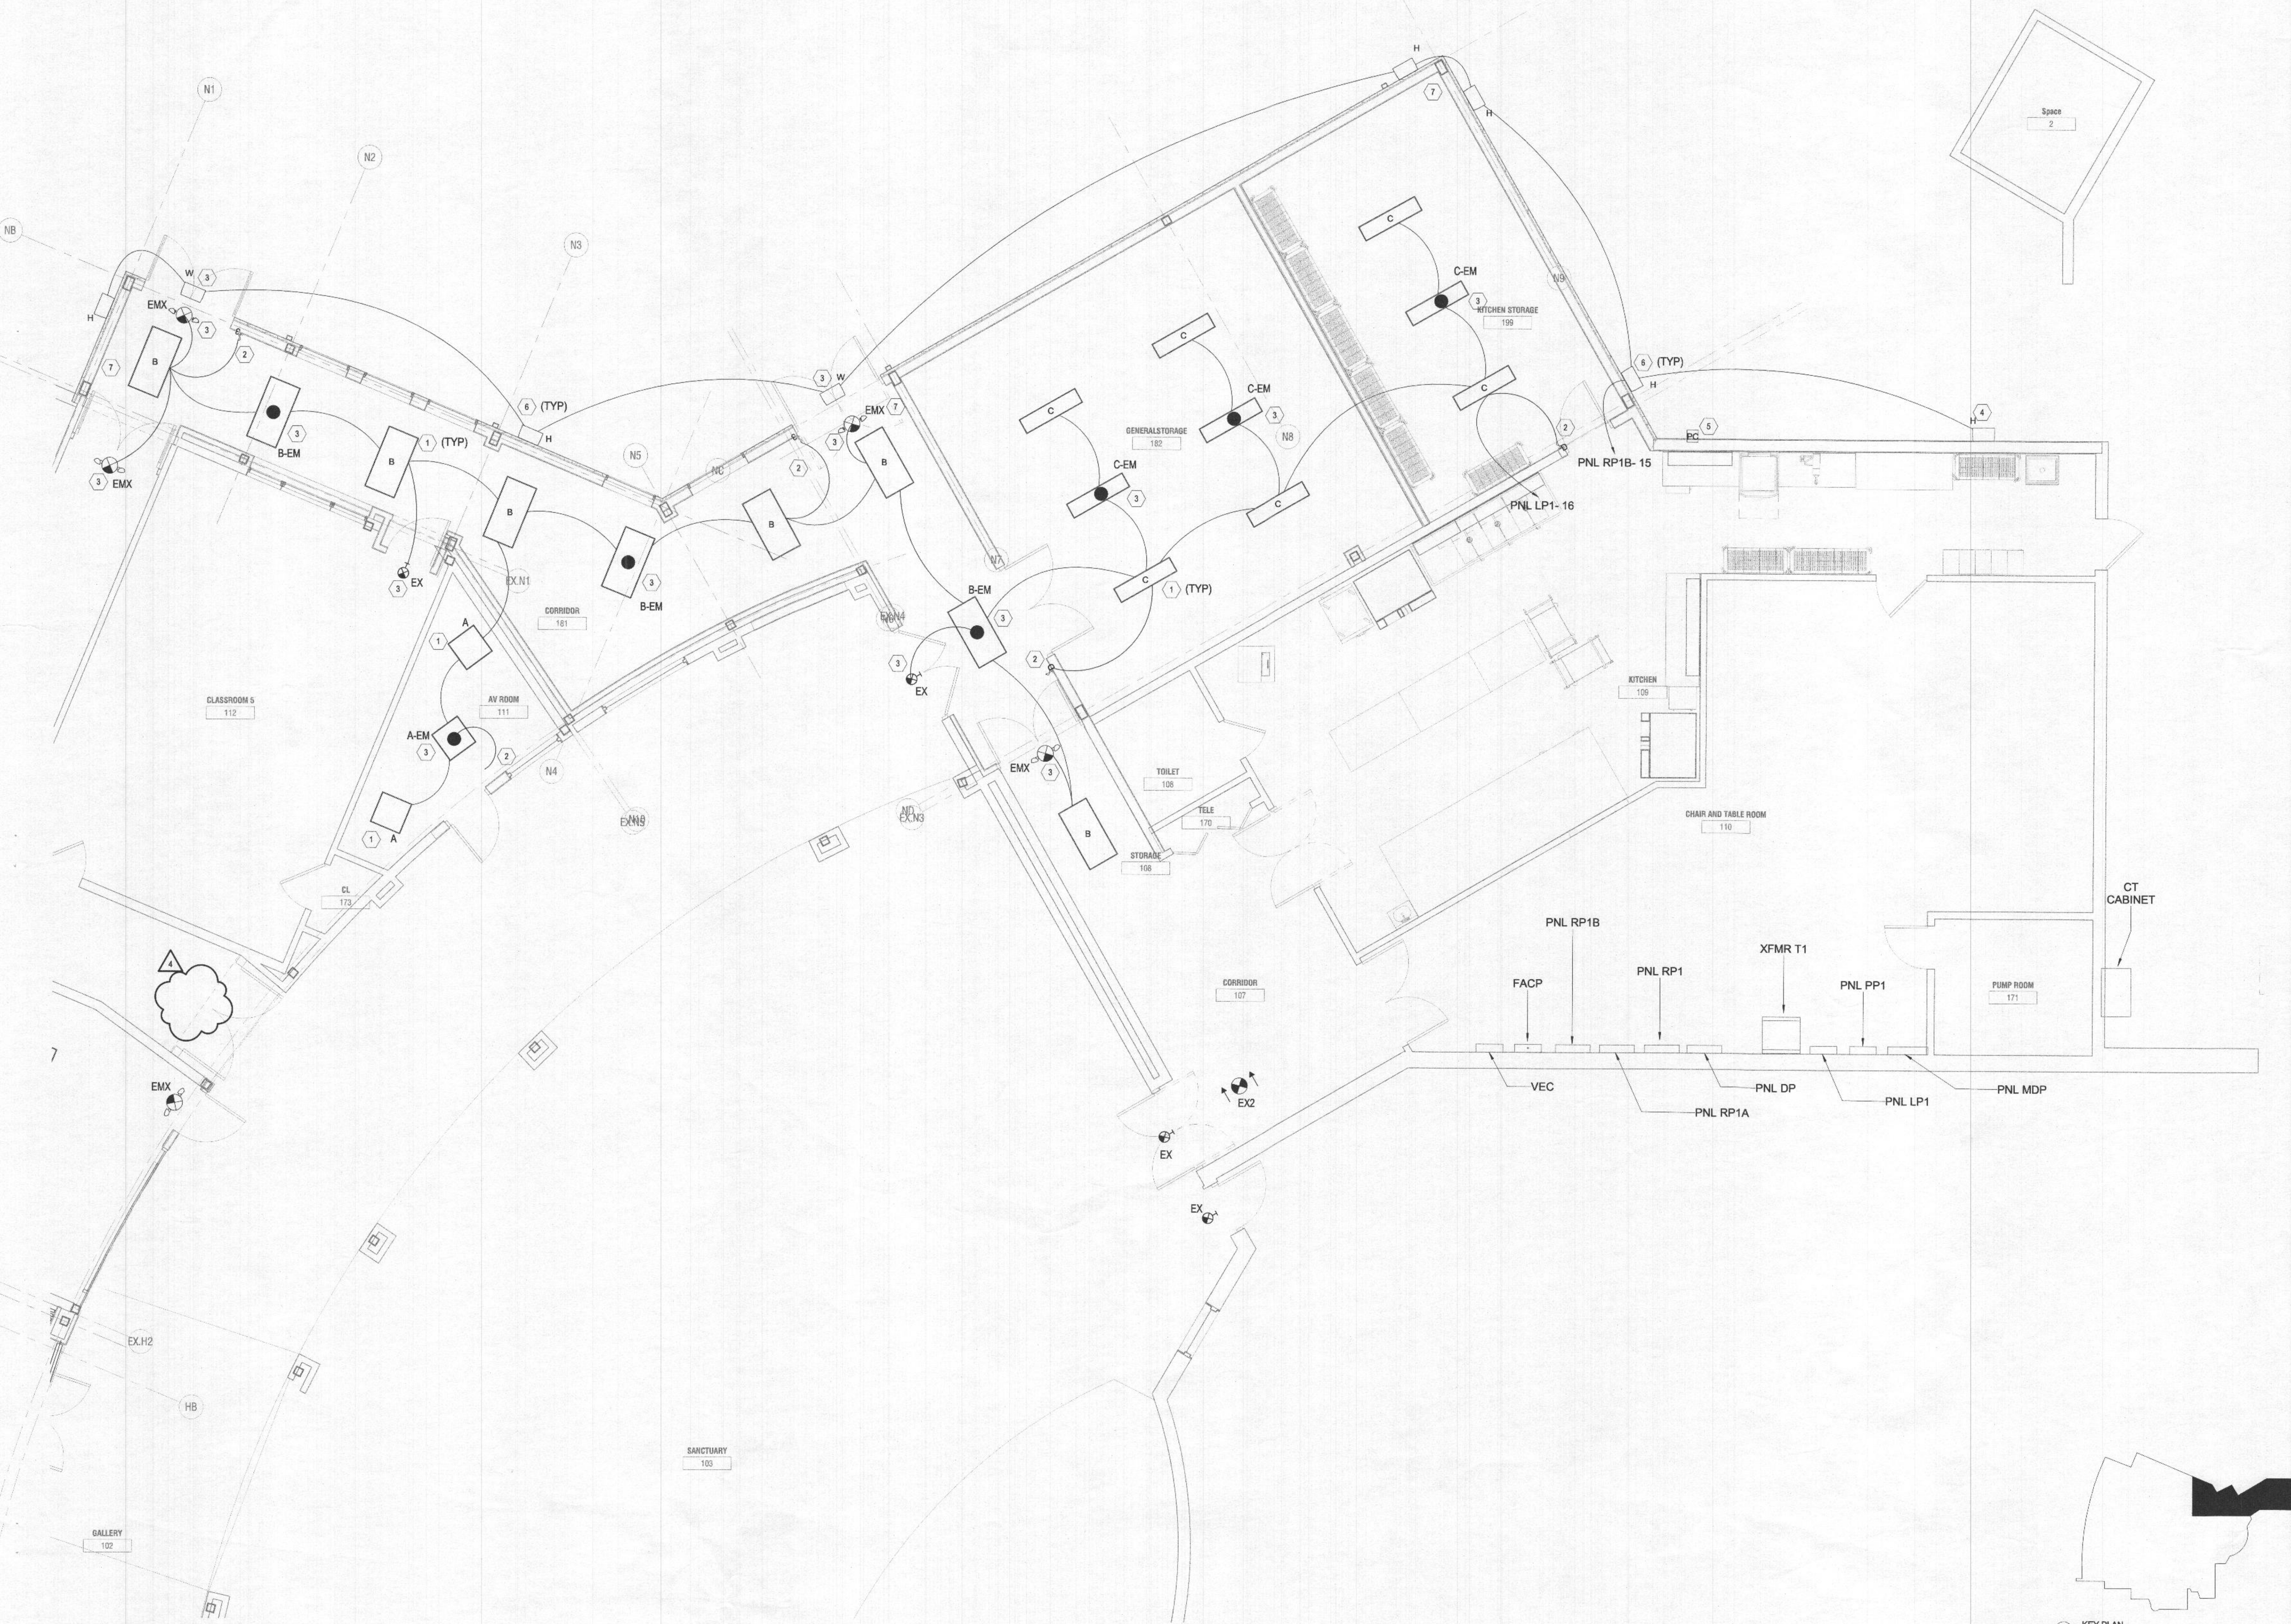

1 ELECTRICAL FIRST FLOOR LIGHTING PLAN - PART C

2 KEY PLAN
NOT TO SCALE

