

I CERTIFY THAT THESE DOCUMENTS WERE PREPARED OR APPROVED BY ME, AND THAT I AM A DULY LICENSED ARCHITECT UNDER THE LAWS OF THE STATE OF MARYLAND, LICENSE NUMBER 13662, EXPIRATION 10-22-2021.

NOTE: THESE DRAWINGS ARE THE PROPERTY OF TRANSFORMING ARCHITECTURE AND, AS SUCH, MAY NOT BE RE-USED OR REPRODUCED, EITHER WHOLLY OR IN PART, WITHOUT PRIOR WRITTEN CONSENT OF TRANSFORMING ARCHITECTURE.

PROJECT PHASE

PERMIT

PROJECT TITLE

# THE CHIORINI- SLAVIN RESIDENCE

14651 Viburnum Dr.  
Dayton, MD 21036

## REVISIONS

SYMBOL	DATE	ISSUED FOR
--------	------	------------

NOV 19 2020

LICENSES & PERMITS  
DIVISION

PROJECT NUMBER	10-043
----------------	--------

DATE	10/27/2020
------	------------


DATE	10/27/2020
SCALE	AS NOTED

DRAWING TITLE


## FIRST FLOOR ELECTRICAL PLAN

SHEET NUMBER

## E-100

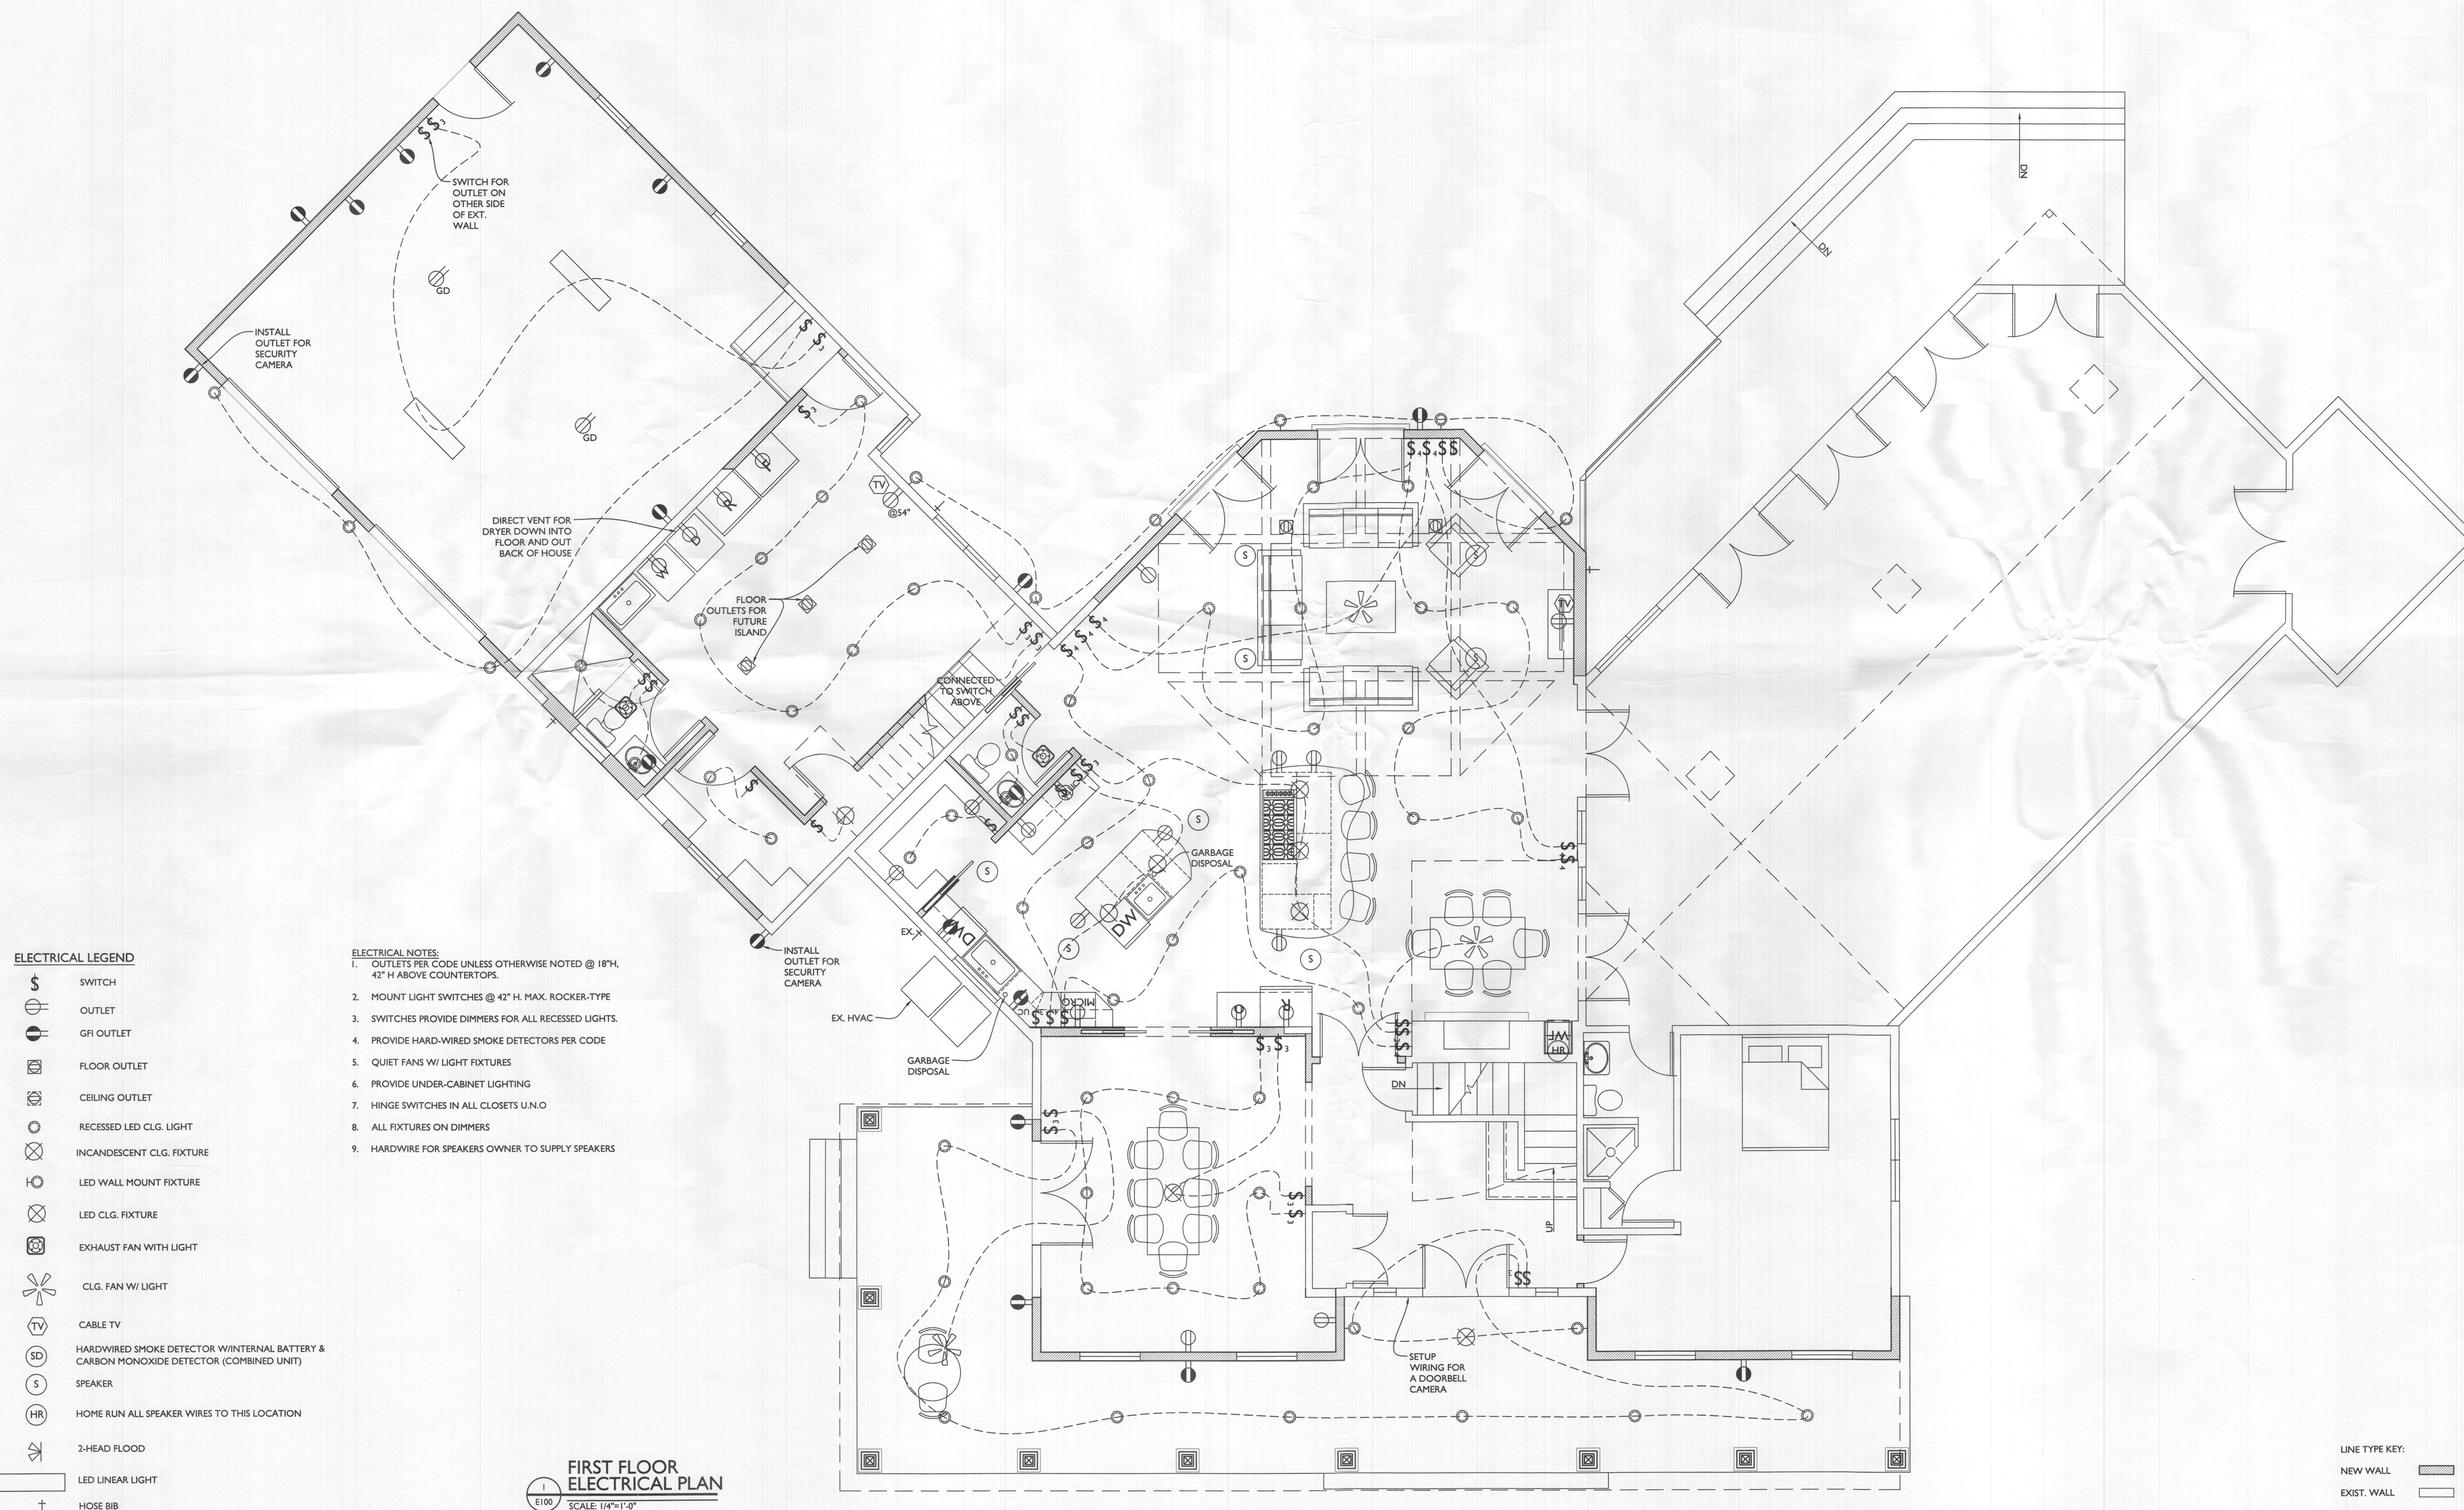



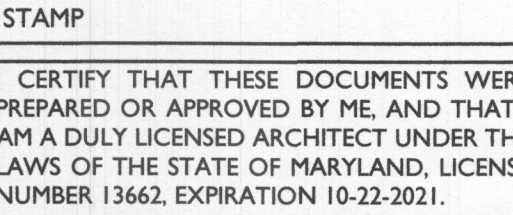

# PERMIT

# THE CHIORINI- SLAVIN RESIDENCE

4651 Viburnum Dr.  
Dayton, MD 21036

## REVISIONS

SYMBOL	DATE	ISSUED FOR
--------	------	------------

RECEIVED

NOV 19 2020

LICENSES & PERMITS  
DIVISION

PROJECT NUMBER 10-04

DATE 10/27/20


SCALE	AS NOTE
-------	---------

DRAWING TITLE



 




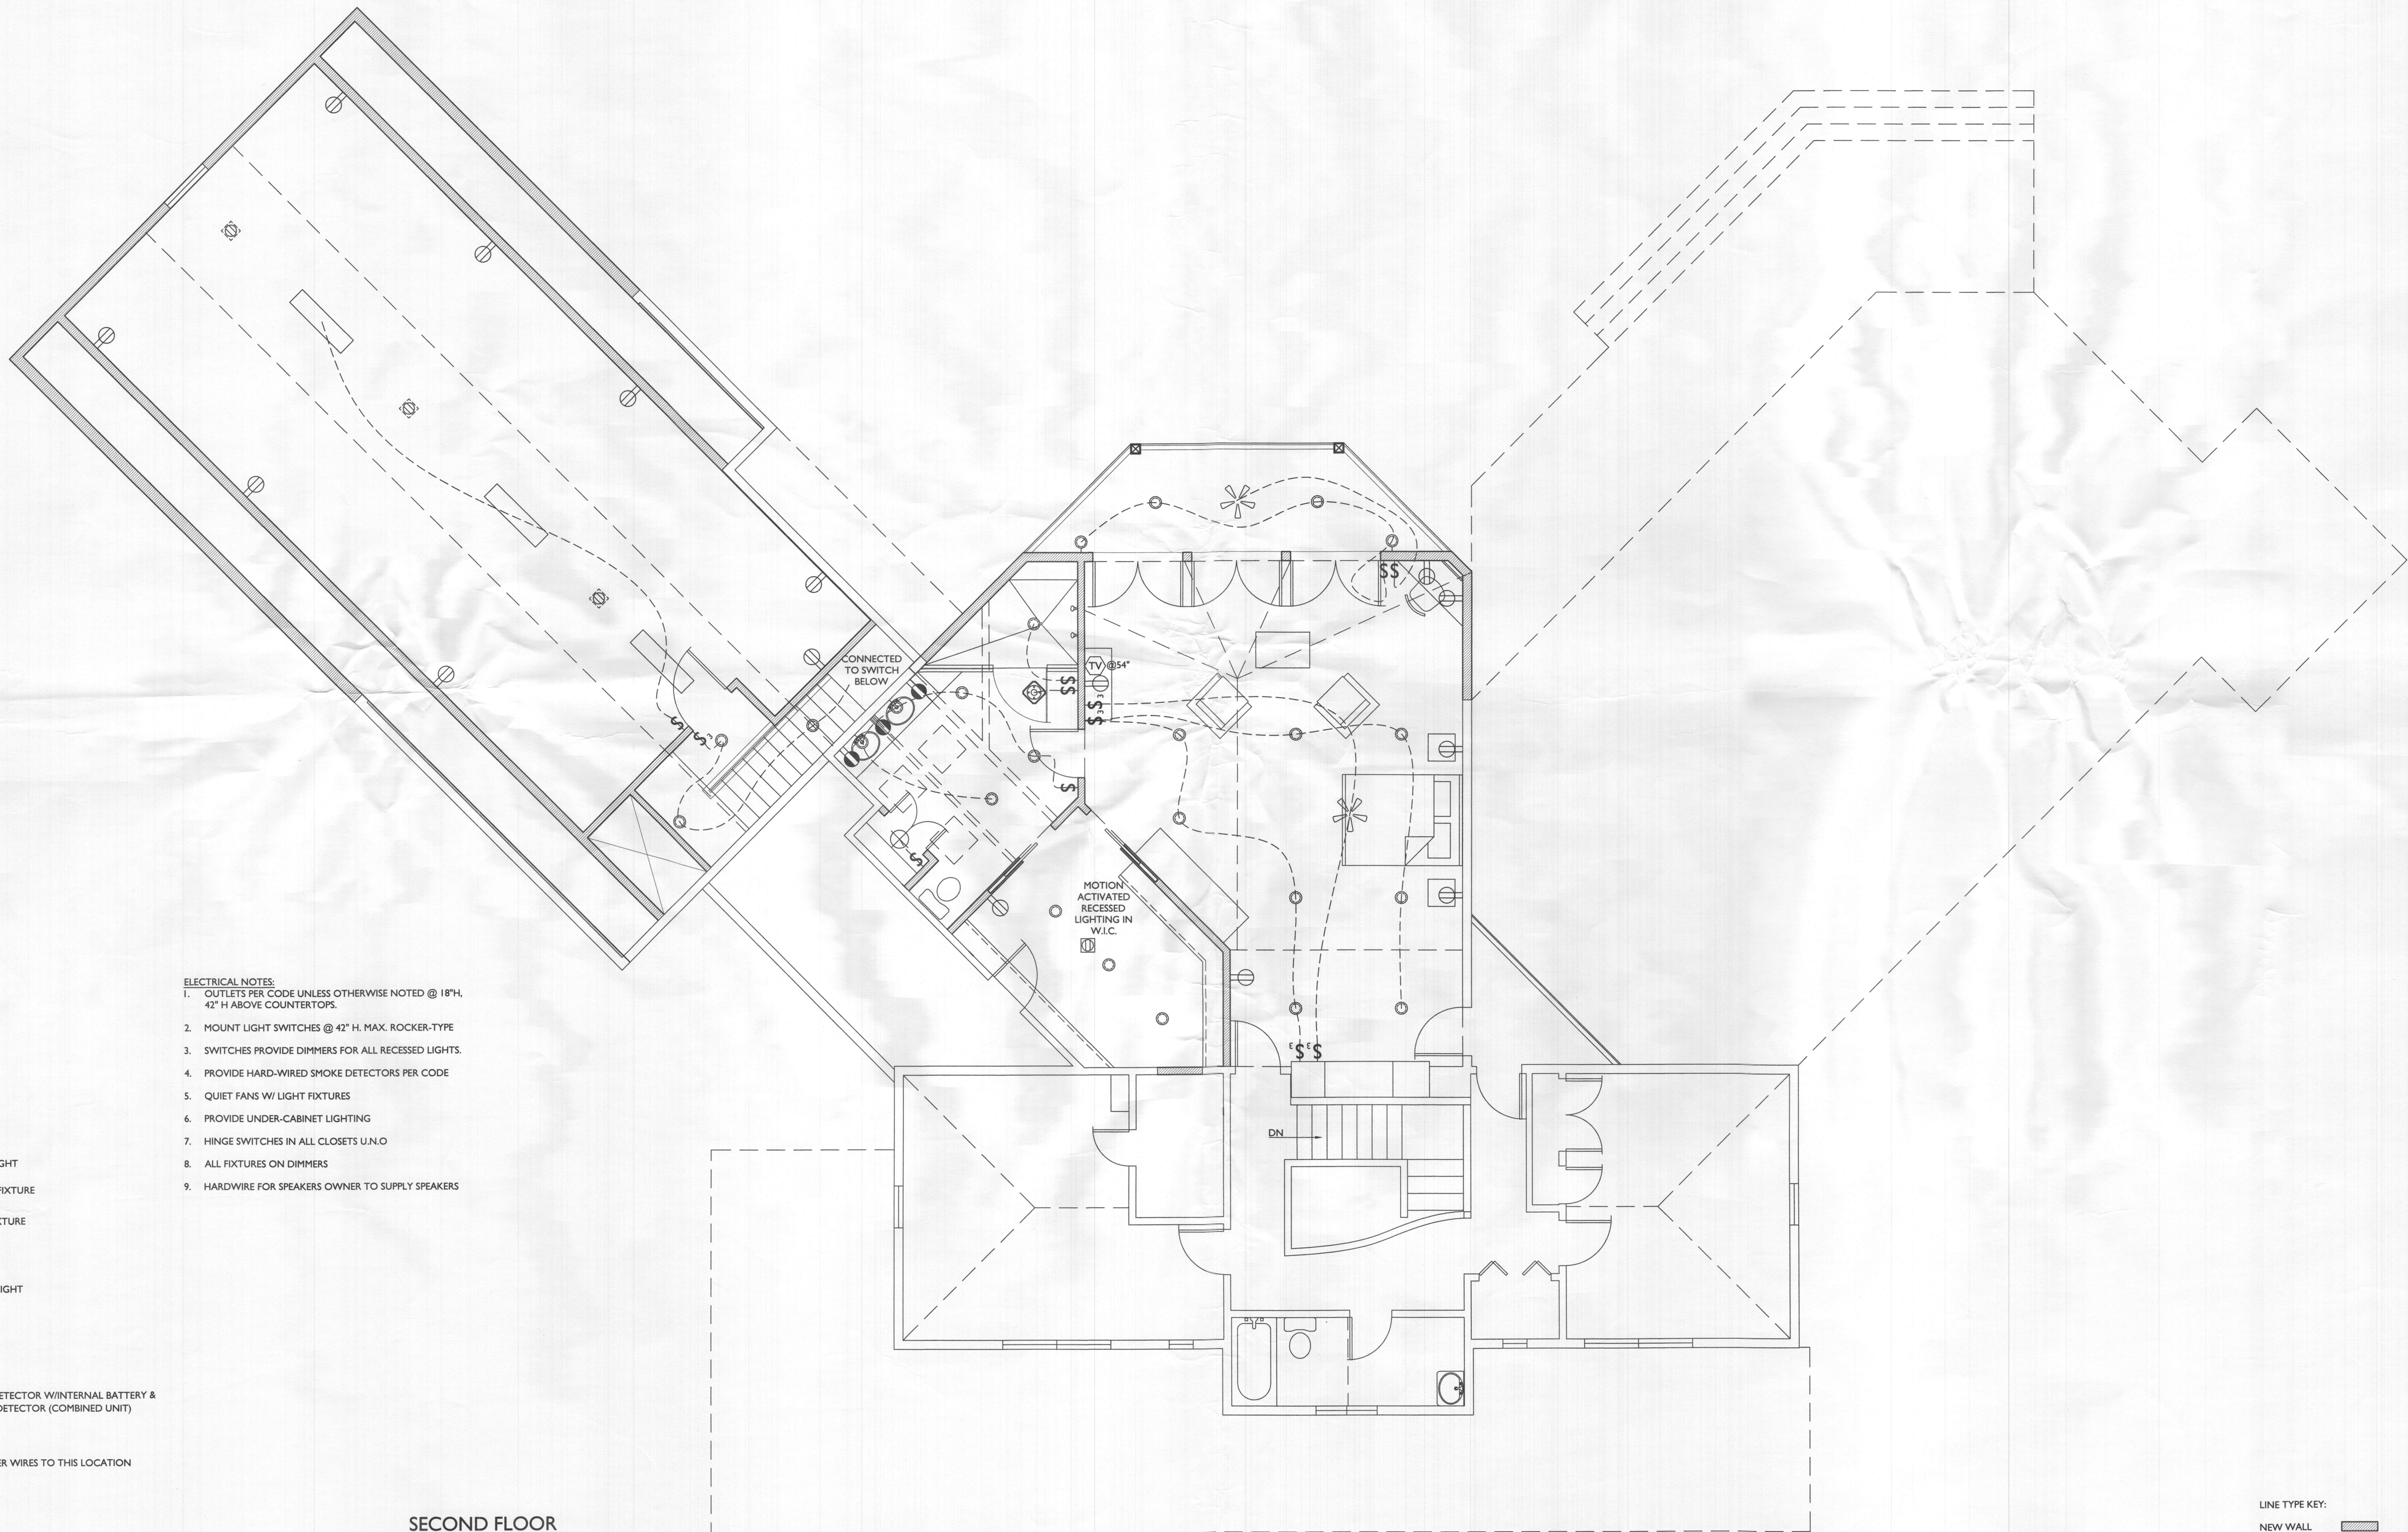










## SECOND FLOOR ELECTRICAL PLAN

SHEET NUMBER

 E-101



### ELECTRICAL LEGEND

- |   |  |
|---|--|
|  | SWITCH   |
|  | OUTLET   |
|  | GFI OUTLET   |
|  | FLOOR OUTLET   |
|  | CEILING OUTLET   |
|  | RECESSED LED CLG. LIGHT  |
|  | INCANDESCENT CLG. FIXTURE  |
|  | LED WALL MOUNT FIXTURE   |
|  | LED CLG. FIXTURE   |
|  | EXHAUST FAN WITH LIGHT   |
|  | CLG. FAN W/ LIGHT  |
|  | CABLE TV   |
|  | HARDWIRED SMOKE DETECTOR W/INTERNAL BATTERY & CARBON MONOXIDE DETECTOR (COMBINED UNIT) |
|  | SPEAKER  |
|  | HOME RUN ALL SPEAKER WIRES TO THIS LOCATION  |
|  | 2-HEAD FLOOD   |
|  | LED LINEAR LIGHT   |
|  | HOSE BIB   |






**ELECTRICAL NOTES:**

1. OUTLETS PER CODE UNLESS OTHERWISE NOTED @ 18" H. 42" H ABOVE COUNTERTOPS.
2. MOUNT LIGHT SWITCHES @ 42" H. MAX. ROCKER-TYPE
3. SWITCHES PROVIDE DIMMERS FOR ALL RECESSED LIGHTS.
4. PROVIDE HARD-WIRED SMOKE DETECTORS PER CODE
5. QUIET FANS W/ LIGHT FIXTURES
6. PROVIDE UNDER-CABINET LIGHTING
7. HINGE SWITCHES IN ALL CLOSETS U.N.O
8. ALL FIXTURES ON DIMMERS
9. HARDWIRE FOR SPEAKERS OWNER TO SUPPLY SPEAKERS

## SECOND FLOOR ELECTRICAL PLAN

E101

LINE TYPE KEY:

- |             |   |
|-------------|---|
| NEW WALL    |  |
| EXIST. WALL |  |
| ABOVE LINE  |  |
| FDN. WALL   |  |
| DEMO WALL   |  |



