

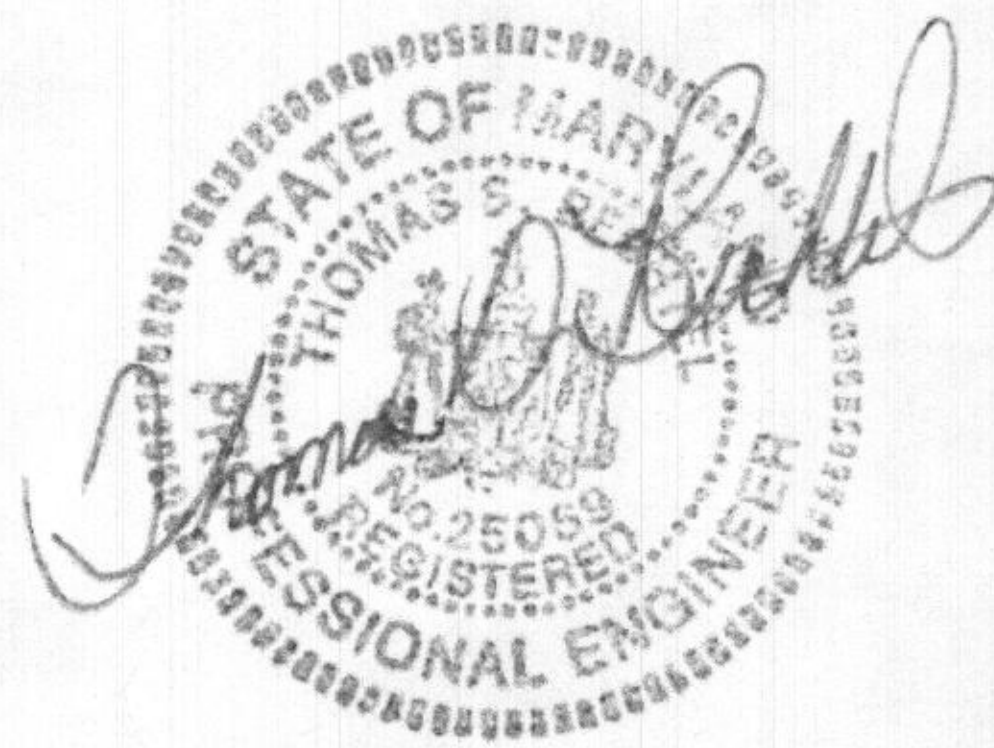


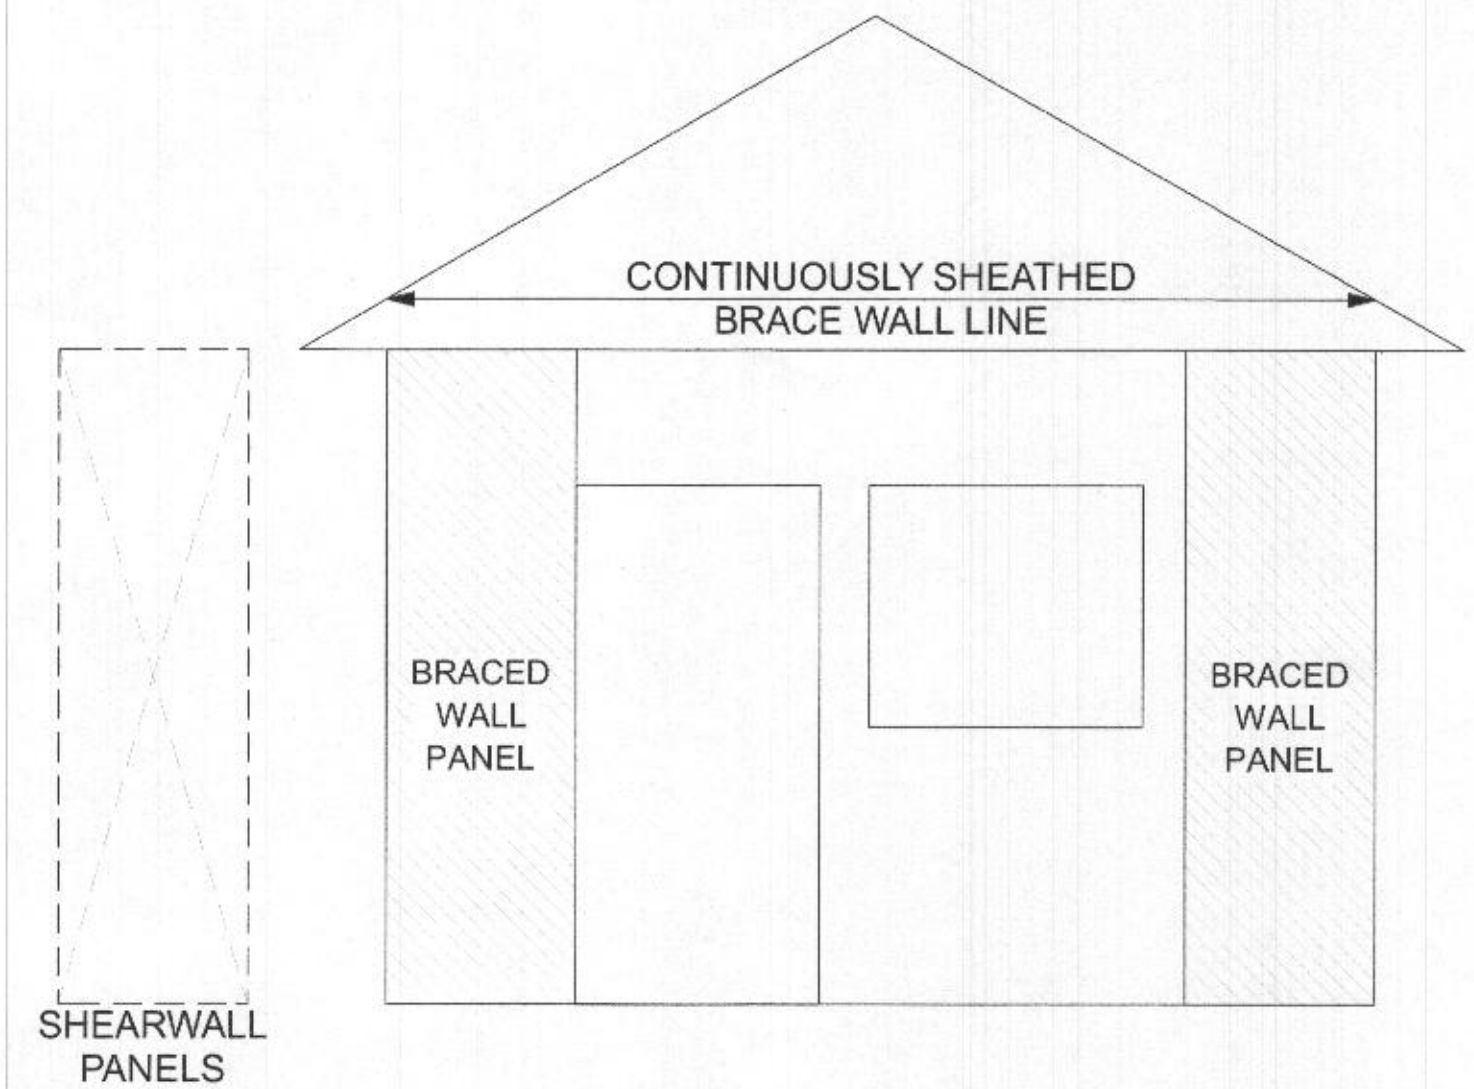


| BRACED WALL SCHEDULE 1ST FLOOR |                   |             |                   |                                                                                           |
|--------------------------------|-------------------|-------------|-------------------|-------------------------------------------------------------------------------------------|
| MARK                           | CONSTRUCTION TYPE | WIND FACTOR | REQ'D LENGTH (FT) | PROVIDED LENGTH (FT) AND DESCRIPTION                                                      |
| BWL-1                          | CS-WSP            | 1.3         | 3.5               | 35.0 +/- LEFT SIDE EXTERIOR WALL                                                          |
| BWL-2                          | GB                | 1.3         | 6.5               | 19' +/- WALL BETWEEN LIBRARY AND FOYER, POWDER ROOM AND HAL                               |
| BWL-3                          | GB                | 1.3         | 6.5               | 15.0 +/- WALL BETWEEN GUEST SUITE AND GRAND ROOM                                          |
| BWL-4                          | CS-WSP/GB         | 1.3         | 6.5               | 3.0 +/- RT SIDE EXT. WALL OF DINING RM AND 15.0' +/- WALL BTWN DINING RM, PANTRY & PDR RM |
| BWL-5                          | CS-WSP            | 1.3         | 6.5               | 9.0 +/- LEFT EXTERIOR WALL OF LOUNGE                                                      |
| BWL-6                          | CS-WSP            | 1.3         | 13.6              | 22.0 +/- RIGHT EXTERIOR WALL OF LOUNGE AND BREAKFAST AREA                                 |
| BWL-A                          | CS-WSP            | 1.3         | 11.7              | 26.5 +/- FRONTBACK EXTERIOR WALL                                                          |
| BWL-B                          | CS-WSP/GB         | 1.3         | 12.5              | 4.0 +/- OF EXTERIOR WALL AND 21.0 +/- CLOSET AND POWDER ROOM WALL                         |
| BWL-C                          | CS-WSP/GB         | 1.3         | 12.5              | 4.0 +/- EXTERIOR WALL AND 30.0 +/- INTERIOR WALL OFF LIBRARY, DINING ROOM AND PANTRY      |
| BWL-D                          | CS-WSP            | 1.3         | 6.5               | 10.0 +/- FRONT EXTERIOR WALL                                                              |

CONSTRUCTION TYPE/BRACING METHODS SHALL BE IN ACCORDANCE WITH TABLE R602.10.4 IN THE IRC.

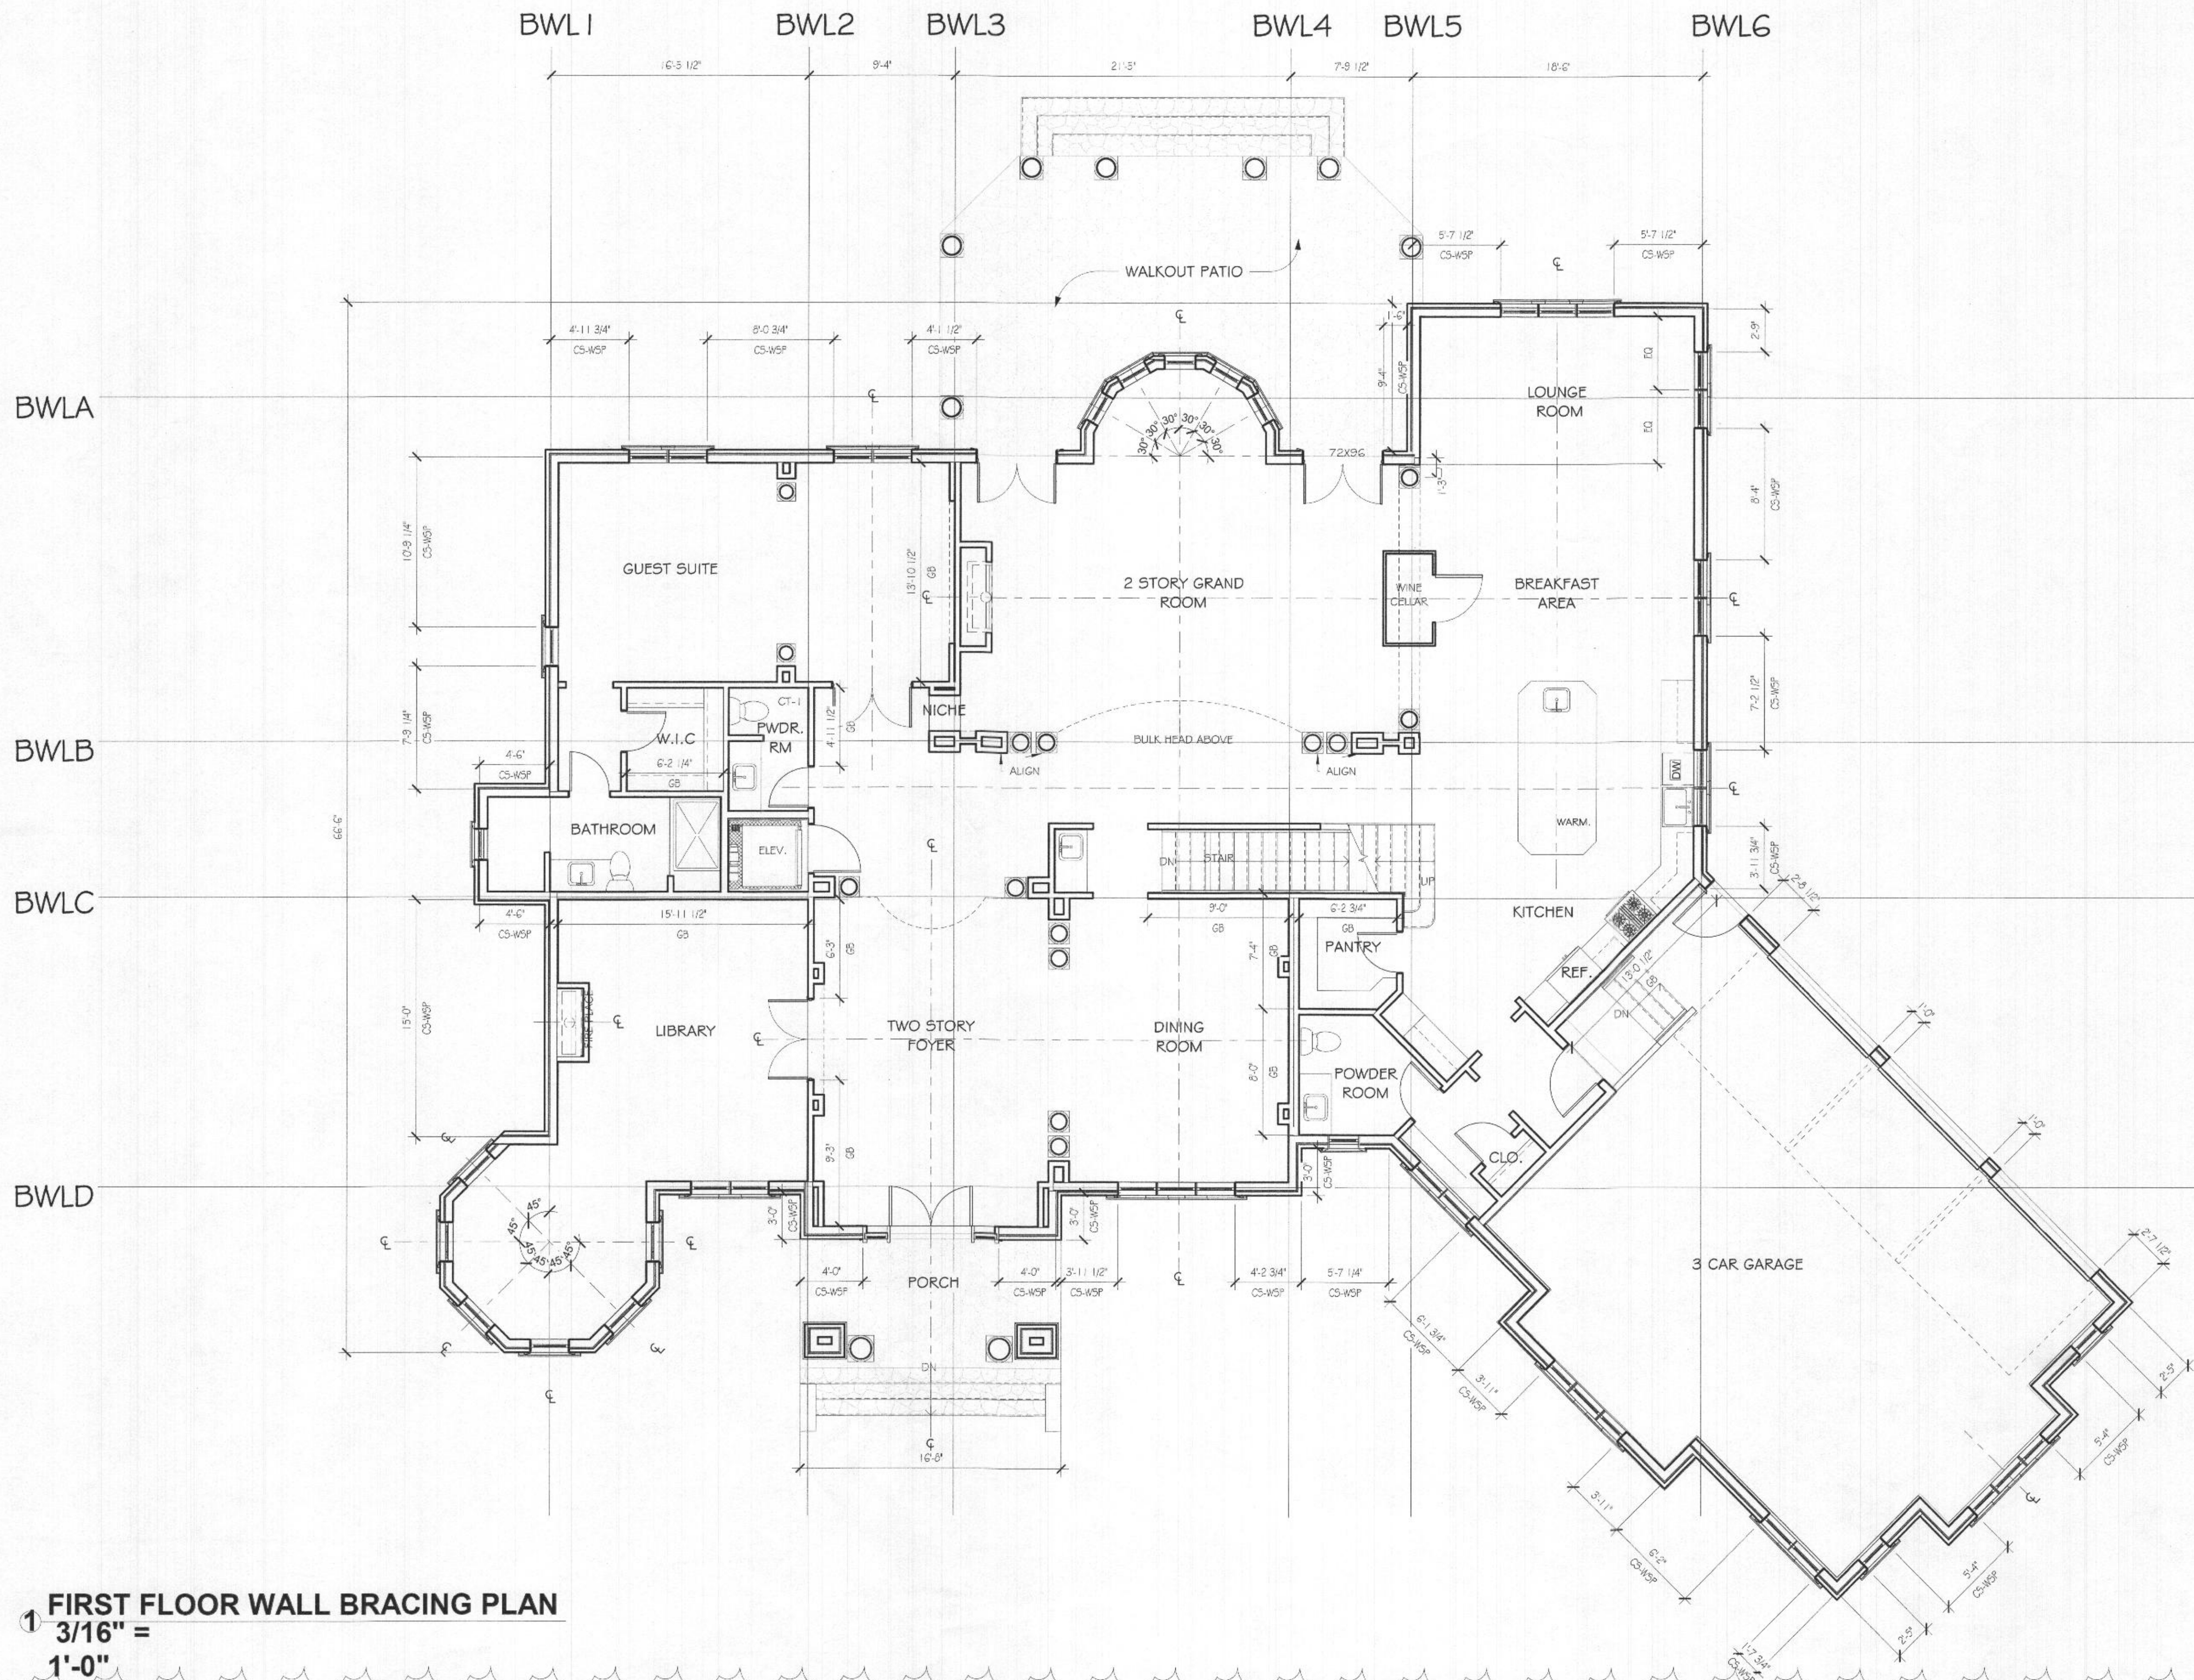


CS-WSP CONT. WOOD STRUCTURAL PANEL METHOD  
8d COMMON NAILS @ 6" EDGE SPACING AND @  
12" FIELD SPACING OR 16 GAGE X 1-3/4" STAPLES  
@ 3" EDGE SPACING AND 6" FIELD SPACING  
MIN. 15/32" APA PLYWOOD SHEATHING OR 3/8" OSB BOARD

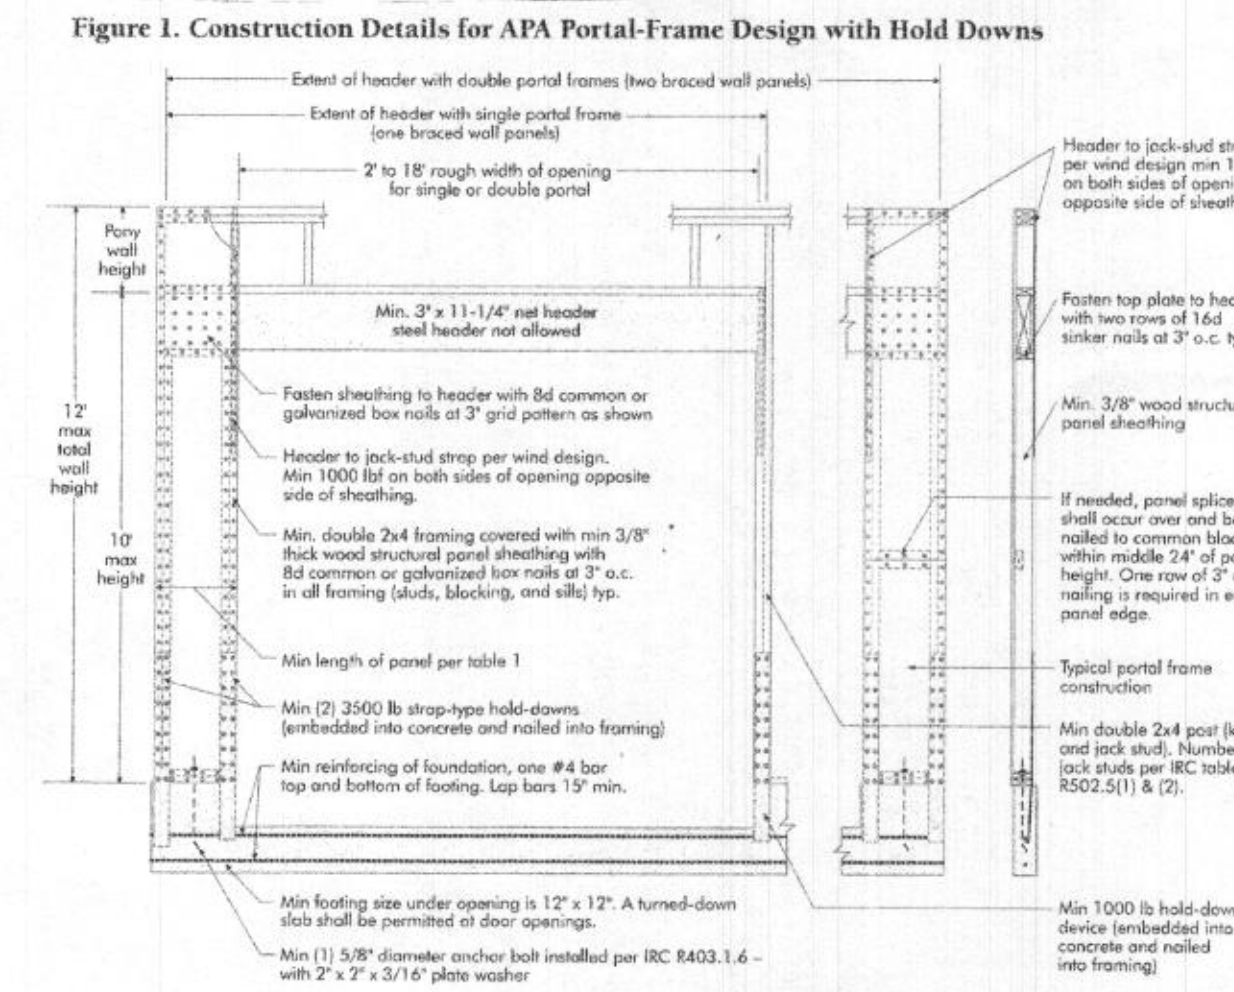

SIMPSON HOW 8-5052.5 W/TRIPLE WALL  
FRAMING AND 7/8 DIAMETER THREADED ROB

SIMPSON HOW 15DS 2.5 W/5-2 WALL  
FRAMING AND SIMPSON SBX30 ANCHOR BOLT  
EMBASEMENT WALL

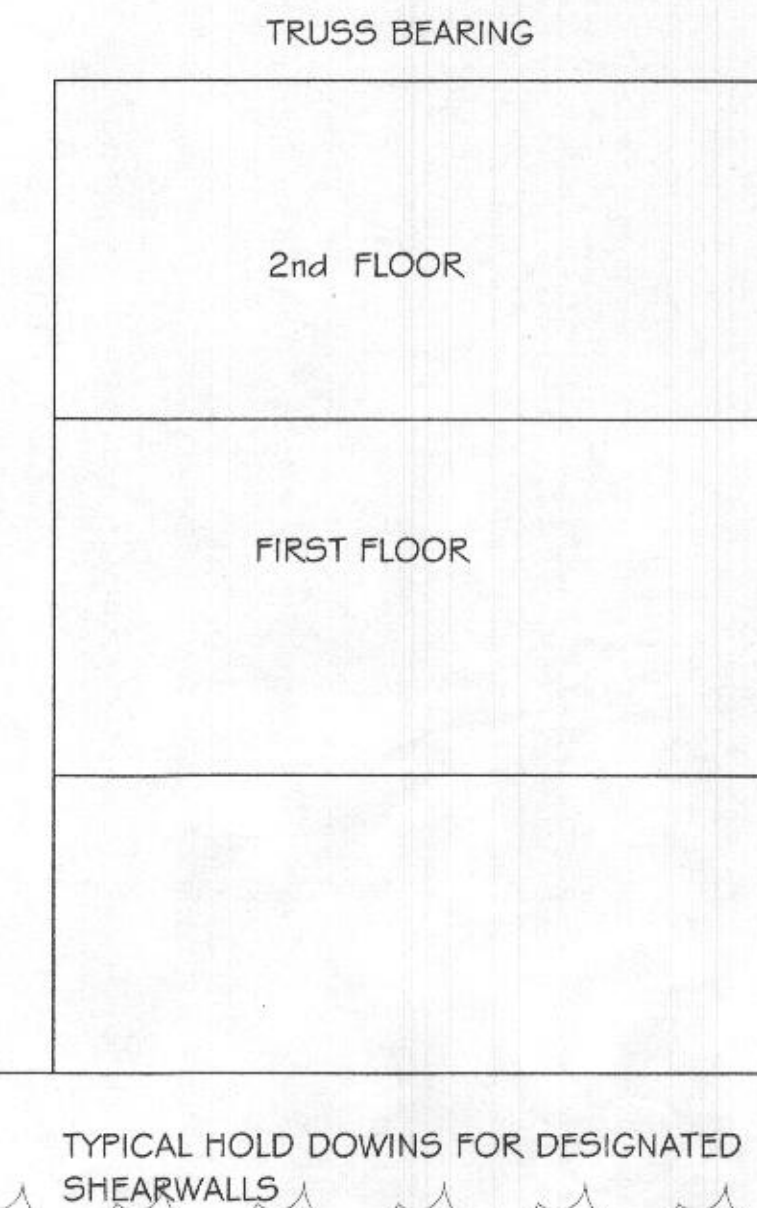

1 FIRST FLOOR WALL BRACING PLAN  
3/16" =  
1'-0"

8030 KAYLADINE LN, LOT 9 DUSTIN'S GOLDEN FIELDS  
FULTON MD 20759 HOWARD COUNTY  
OGUEJIOFOR RESIDENCE

Issued Date  
06/28/20

PROFESSIONAL  
CERTIFICATION

I CERTIFY THAT THESE  
DOCUMENTS WERE PREPARED  
OR APPROVED BY ME, AND  
THAT I AM A DULY LICENSED  
ARCHITECT UNDER THE LAWS  
OF THE STATE OF MARYLAND.

LICENSE #:

EXPIRATION:


FIRST  
FLOOR  
WALL  
BRACING  
PLAN  
WB.1

bethe! Architecture & Construction Management  
4015 Prince Georges Avenue,  
Suite 204  
Baltimore, Maryland 20705  
Tel: 301.937.7500  
Fax: 301.937.7571

The Design / Drawings remain the property of  
the Architect. Bethel Design Group LLC  
Unauthorized reproduction for any purpose is an  
infringement upon copyright laws. Violations will  
be subject to prosecution by the fullest extent of  
the law.



Written dimensions on these drawings shall  
have precedence over scale dimensions.  
Contractors shall verify and be responsible for  
all dimensions and conditions on the job and this  
office shall be relieved of any variation from the  
dimensions and conditions shown by these  
drawings.

Permit Stamp


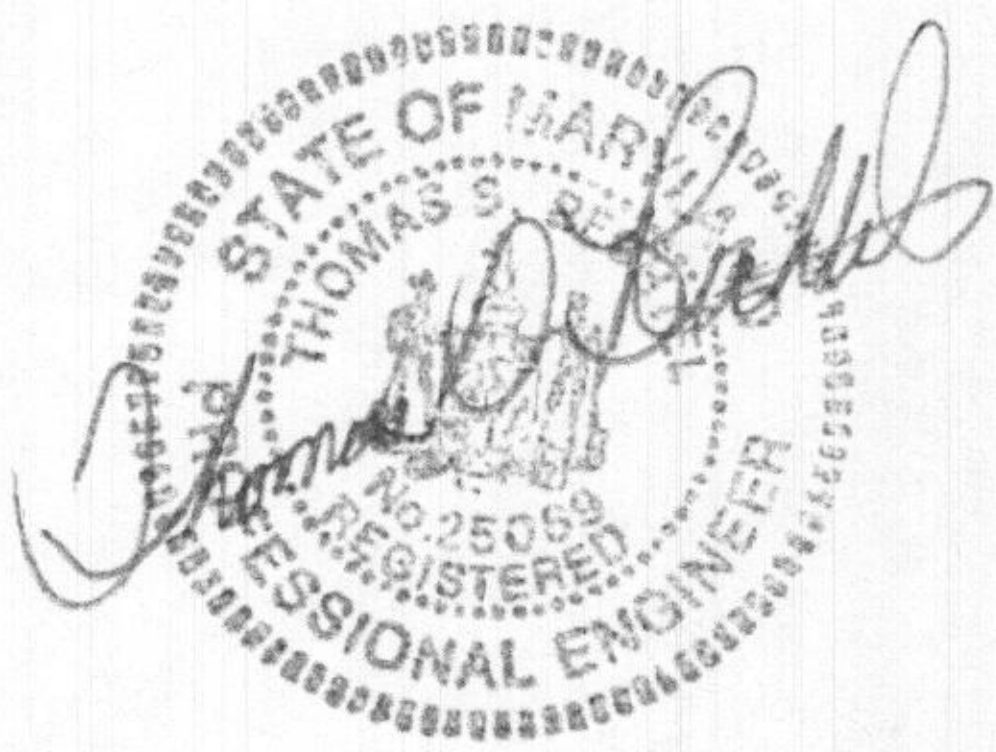


| BRACED WALL SCHEDULE 2ND FLOOR |                   |             |                  |                                                                                                     |
|--------------------------------|-------------------|-------------|------------------|-----------------------------------------------------------------------------------------------------|
| MARK                           | CONSTRUCTION TYPE | WIND FACTOR | REQD LENGTH (FT) | PROVIDED LENGTH (FT) AND DESCRIPTION                                                                |
| BWL-1                          | CS-WSP            | 1.3         | 3.5              | 35.0 +/- LEFT EXTERIOR WALL                                                                         |
| BWL-2                          | CS-WSP/GB         | 1.3         | 12.5             | 3.0 +/- SIDE EXT. WALL OFF FRONT ENTRANCE AND 22.0 +/- INT. WALL BTWN MSTR BDRM AND FOYR            |
| BWL-3                          | GB                | 1.3         | 6.5              | 20.0 +/- INTERIOR WALL BETWEEN MASTER CLOSET AND GRAND ROOM                                         |
| BWL-4                          | CS-WSP/GB         | 1.3         | 12.5             | 3.0 +/- SIDE EXT. WALL OFF FRONT ENTRANCE AND 22.0 +/- INT. WALL BTWN BEDROOM 1 AND FOYR            |
| BWL-5                          | CS-WSP/GB         | 1.3         | 12.4             | 9.0 +/- LEFT EXTERIOR WALL OF LOUNGE AND 16.0 +/- INTERIOR WALL BETWEEN GRAND ROOM AND BEDROOM 2    |
| BWL-6                          | CS-WSP            | 1.3         | 6.5              | 19.0 +/- RIGHT EXTERIOR WALL OFF BEDROOM #2 AND LAUNDRY ROOM                                        |
| BWL-A                          | CS-WSP            | 1.3         | 8.5              | 25.5 +/- BACK EXTERIOR WALL +/- 4'-0" OFF BWL-A                                                     |
| BWL-B                          | GB                | 1.3         | 9.5              | 46.0 +/- INTERIOR WALLS OF MASTER BATHROOM, CLOSET AND BATHROOM 2                                   |
| BWL-C                          | CS-WSP/GB         | 1.3         | 9.5              | 4.0 +/- EXTERIOR WALL AND 52.0 +/- INTERIOR WALLS 4' +/- OFF BWL-C BTWN CLOSET, ELEVATOR AND STAIRS |
| BWL-D                          | CS-WSP            | 1.3         | 6.5              | 9.0 +/- FRONT EXTERIOR WALL                                                                         |

CONSTRUCTION TYPE/BRACING METHODS SHALL BE IN ACCORDANCE WITH TABLE R602.10.4 IN THE IRC.

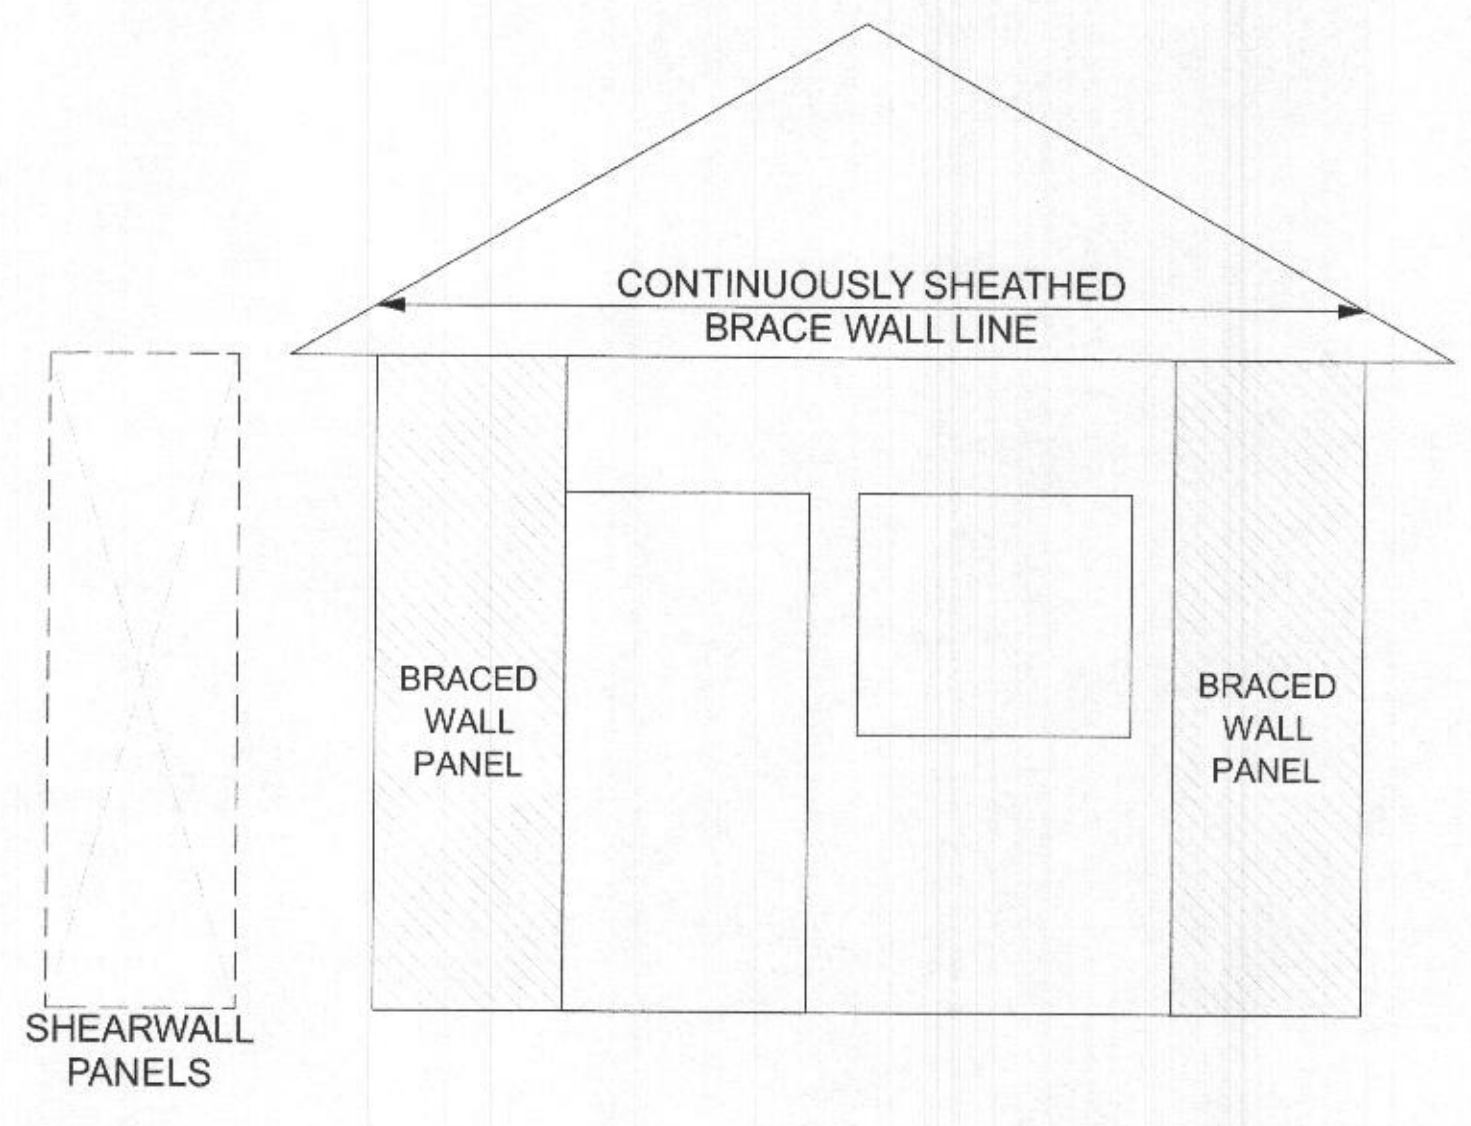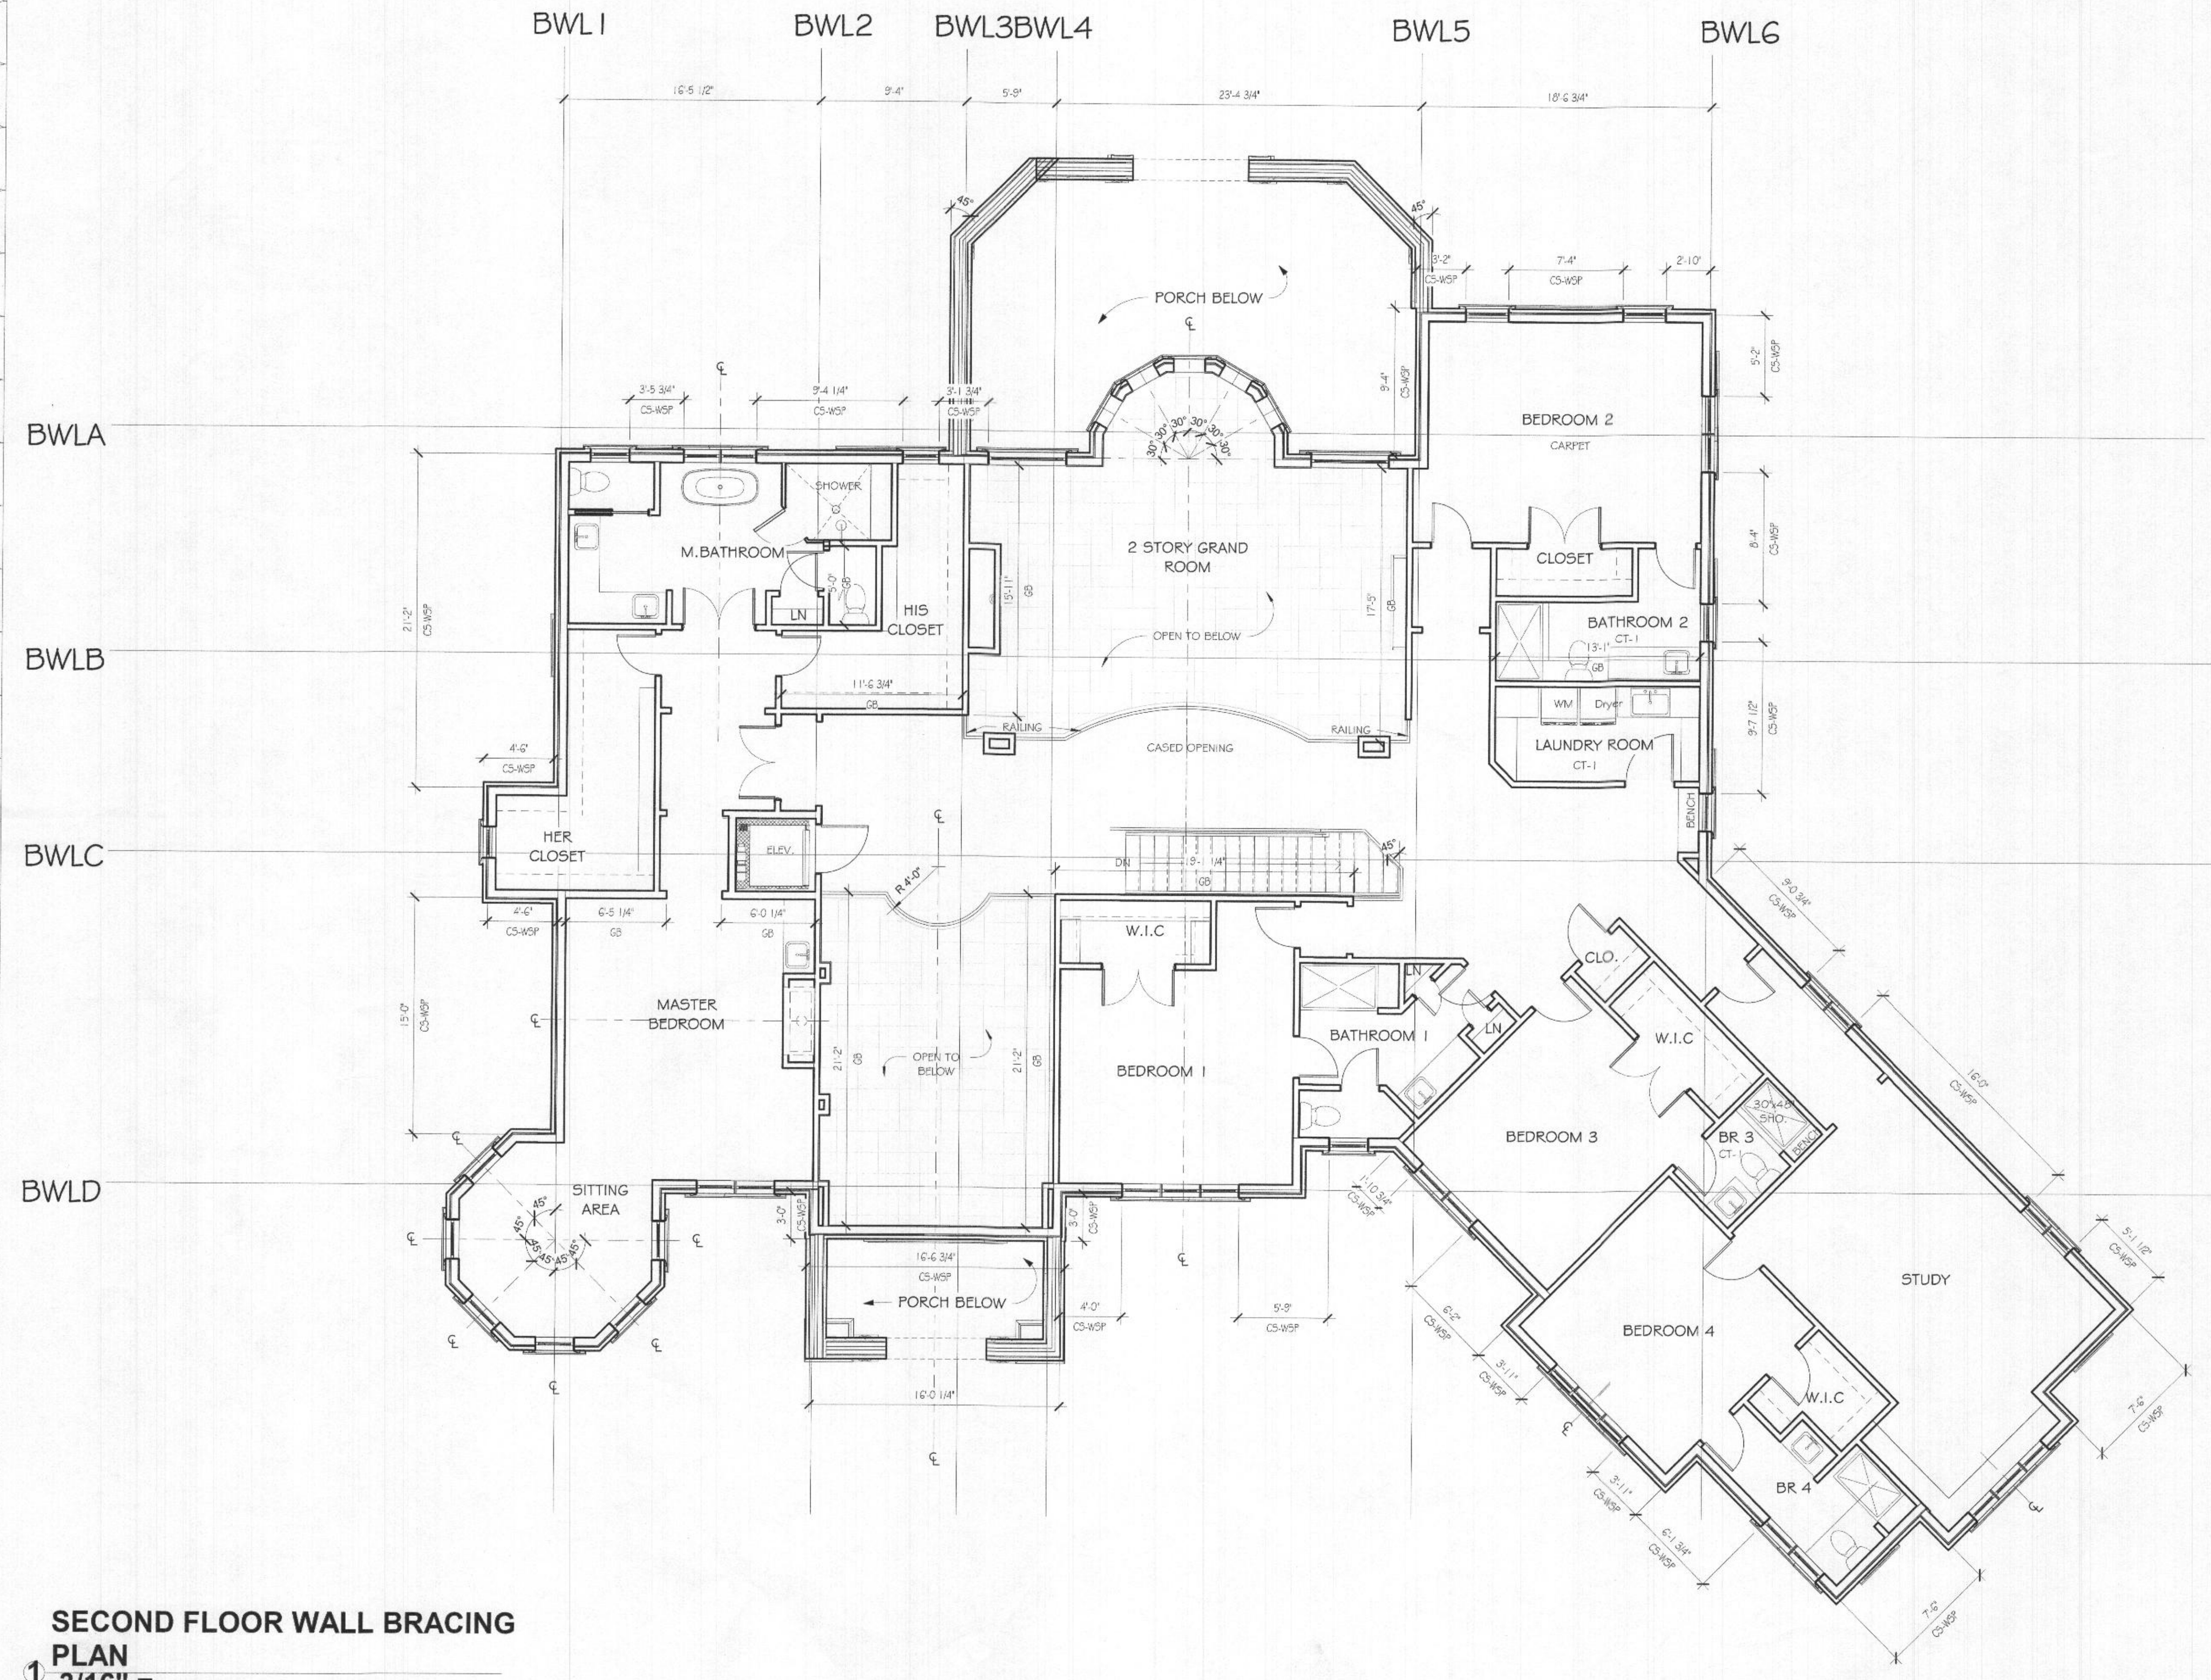

CS-WSP CONT. WOOD STRUCTURAL PANEL METHOD  
8d COMMON NAILS @ 6" EDGE SPACING AND @ 12" FIELD SPACING OR 16 GAGE X 1-3/4" STAPLES @ 3" EDGE SPACING AND 6" FIELD SPACING  
MIN. 15/32" APA PLYWOOD SHEATHING OR 3/8" OSB BOARD

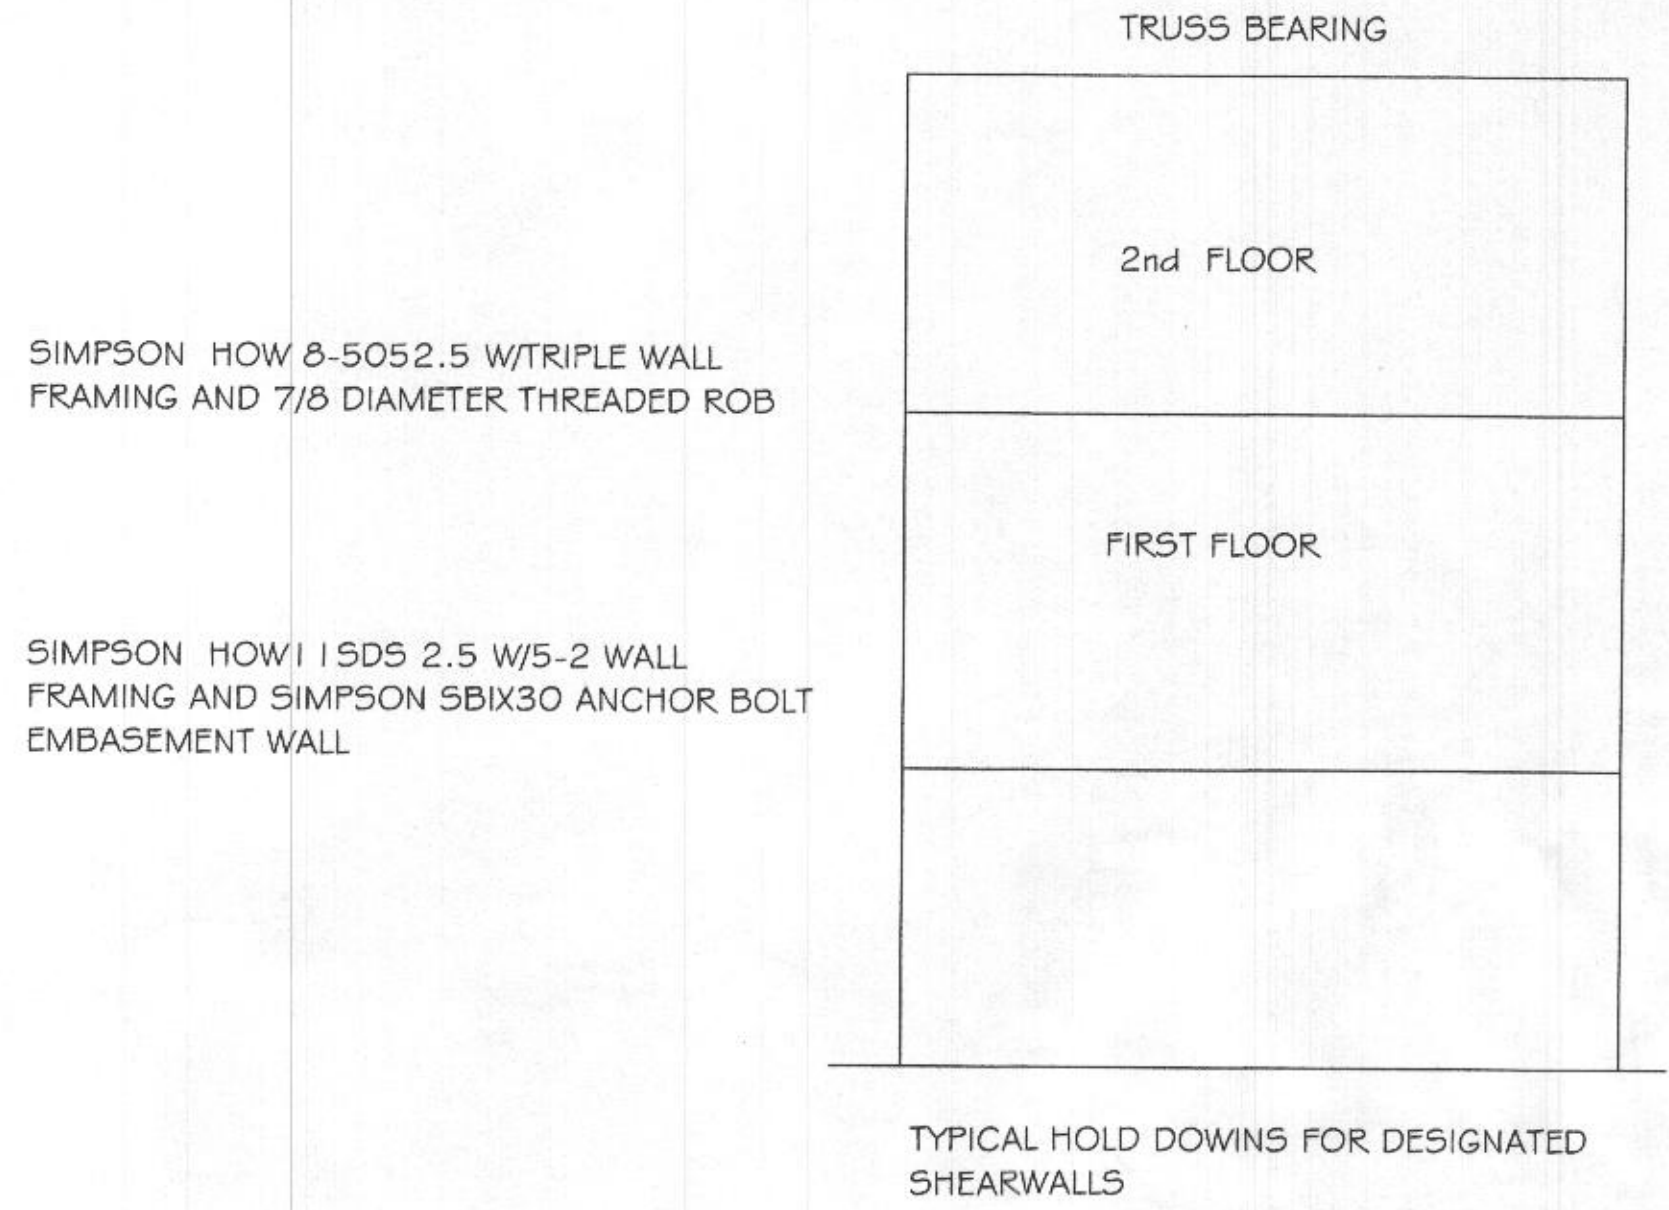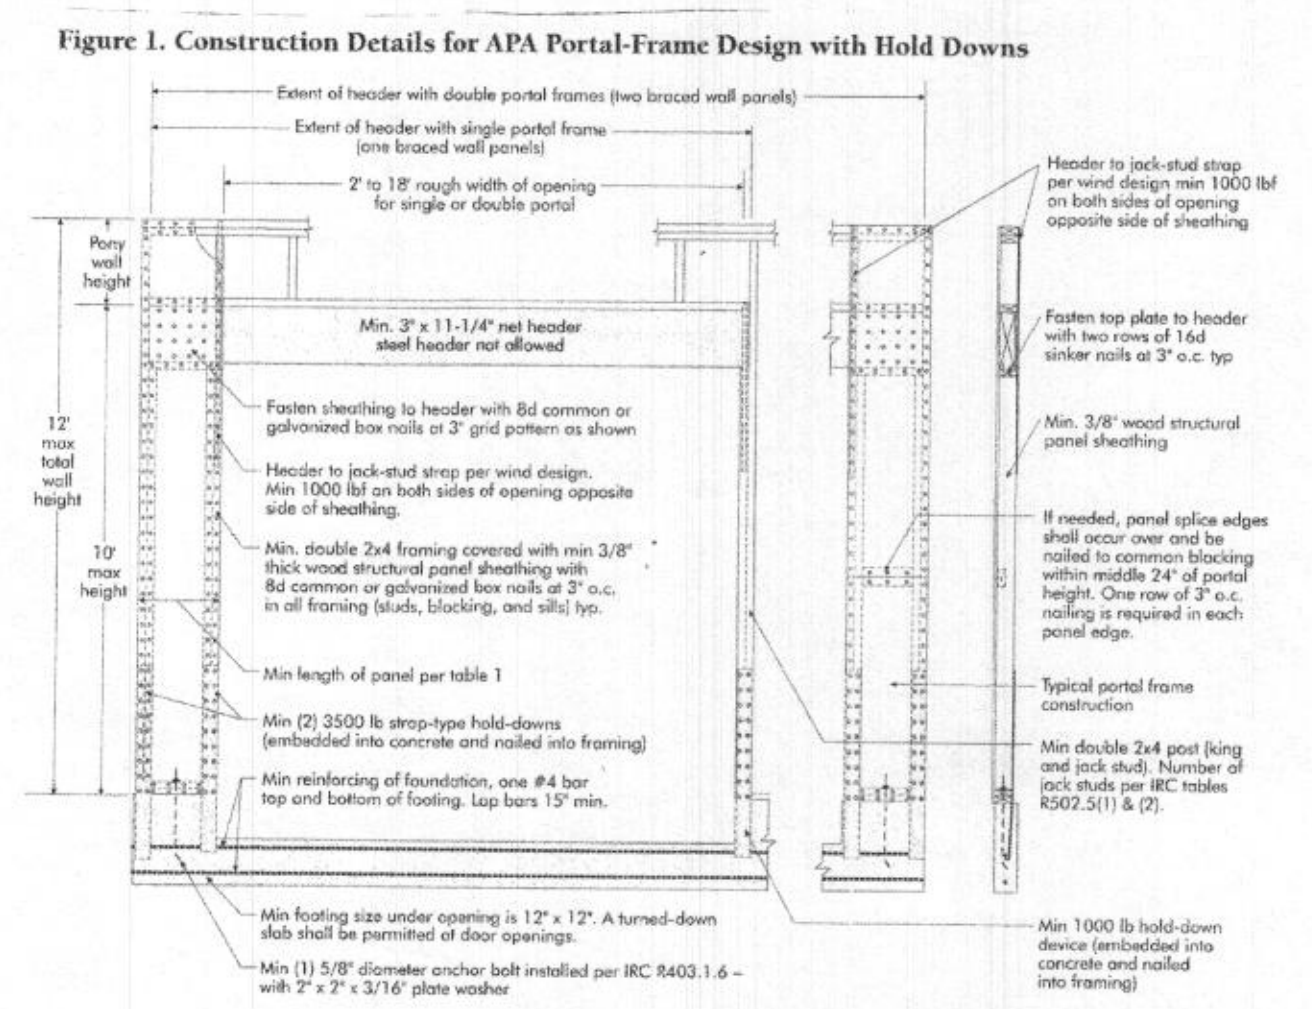

SECOND FLOOR WALL BRACING  
PLAN  
1/316" =  
1'-0"

Architecture & Construction Management  
4015 Prince Georges Avenue,  
Suite 204  
Baltimore, Maryland 21205  
Tel: 301.937.7500  
Fax: 301.937.7571

The Design/Drawings remain the property of the Architect, Betnel Design Construct, Inc. Unlicensed reproduction for any purpose is an infringement under copyright law. Violations will be subject to prosecution by the federal estate of the law.

Further dimensions on these drawings shall have precedence over scale dimensions. Contractors shall verify and be responsible for all dimensions and conditions on the job and the drawings must be modified if any variation from the dimensions and conditions shown by these drawings.

8030 KAYLADINE LN, LOT 9 DUSTIN'S GOLDEN FIELDS  
FULTON MD 20759 HOWARD COUNTY  
OGUEJIOFOR RESIDENCE


|          |           |
|----------|-----------|
| Issued   | Date      |
| Revision | 1/13/2020 |

PROFESSIONAL CERTIFICATION

CERTIFY THAT THESE DOCUMENTS WERE PREPARED OR APPROVED BY ME, AND THAT I AM A DULY LICENSED ARCHITECT UNDER THE LAWS OF THE STATE OF MARYLAND.

LICENSE #:  
EXPIRATION:


SECOND FLOOR WALL BRACING PLAN WB.2

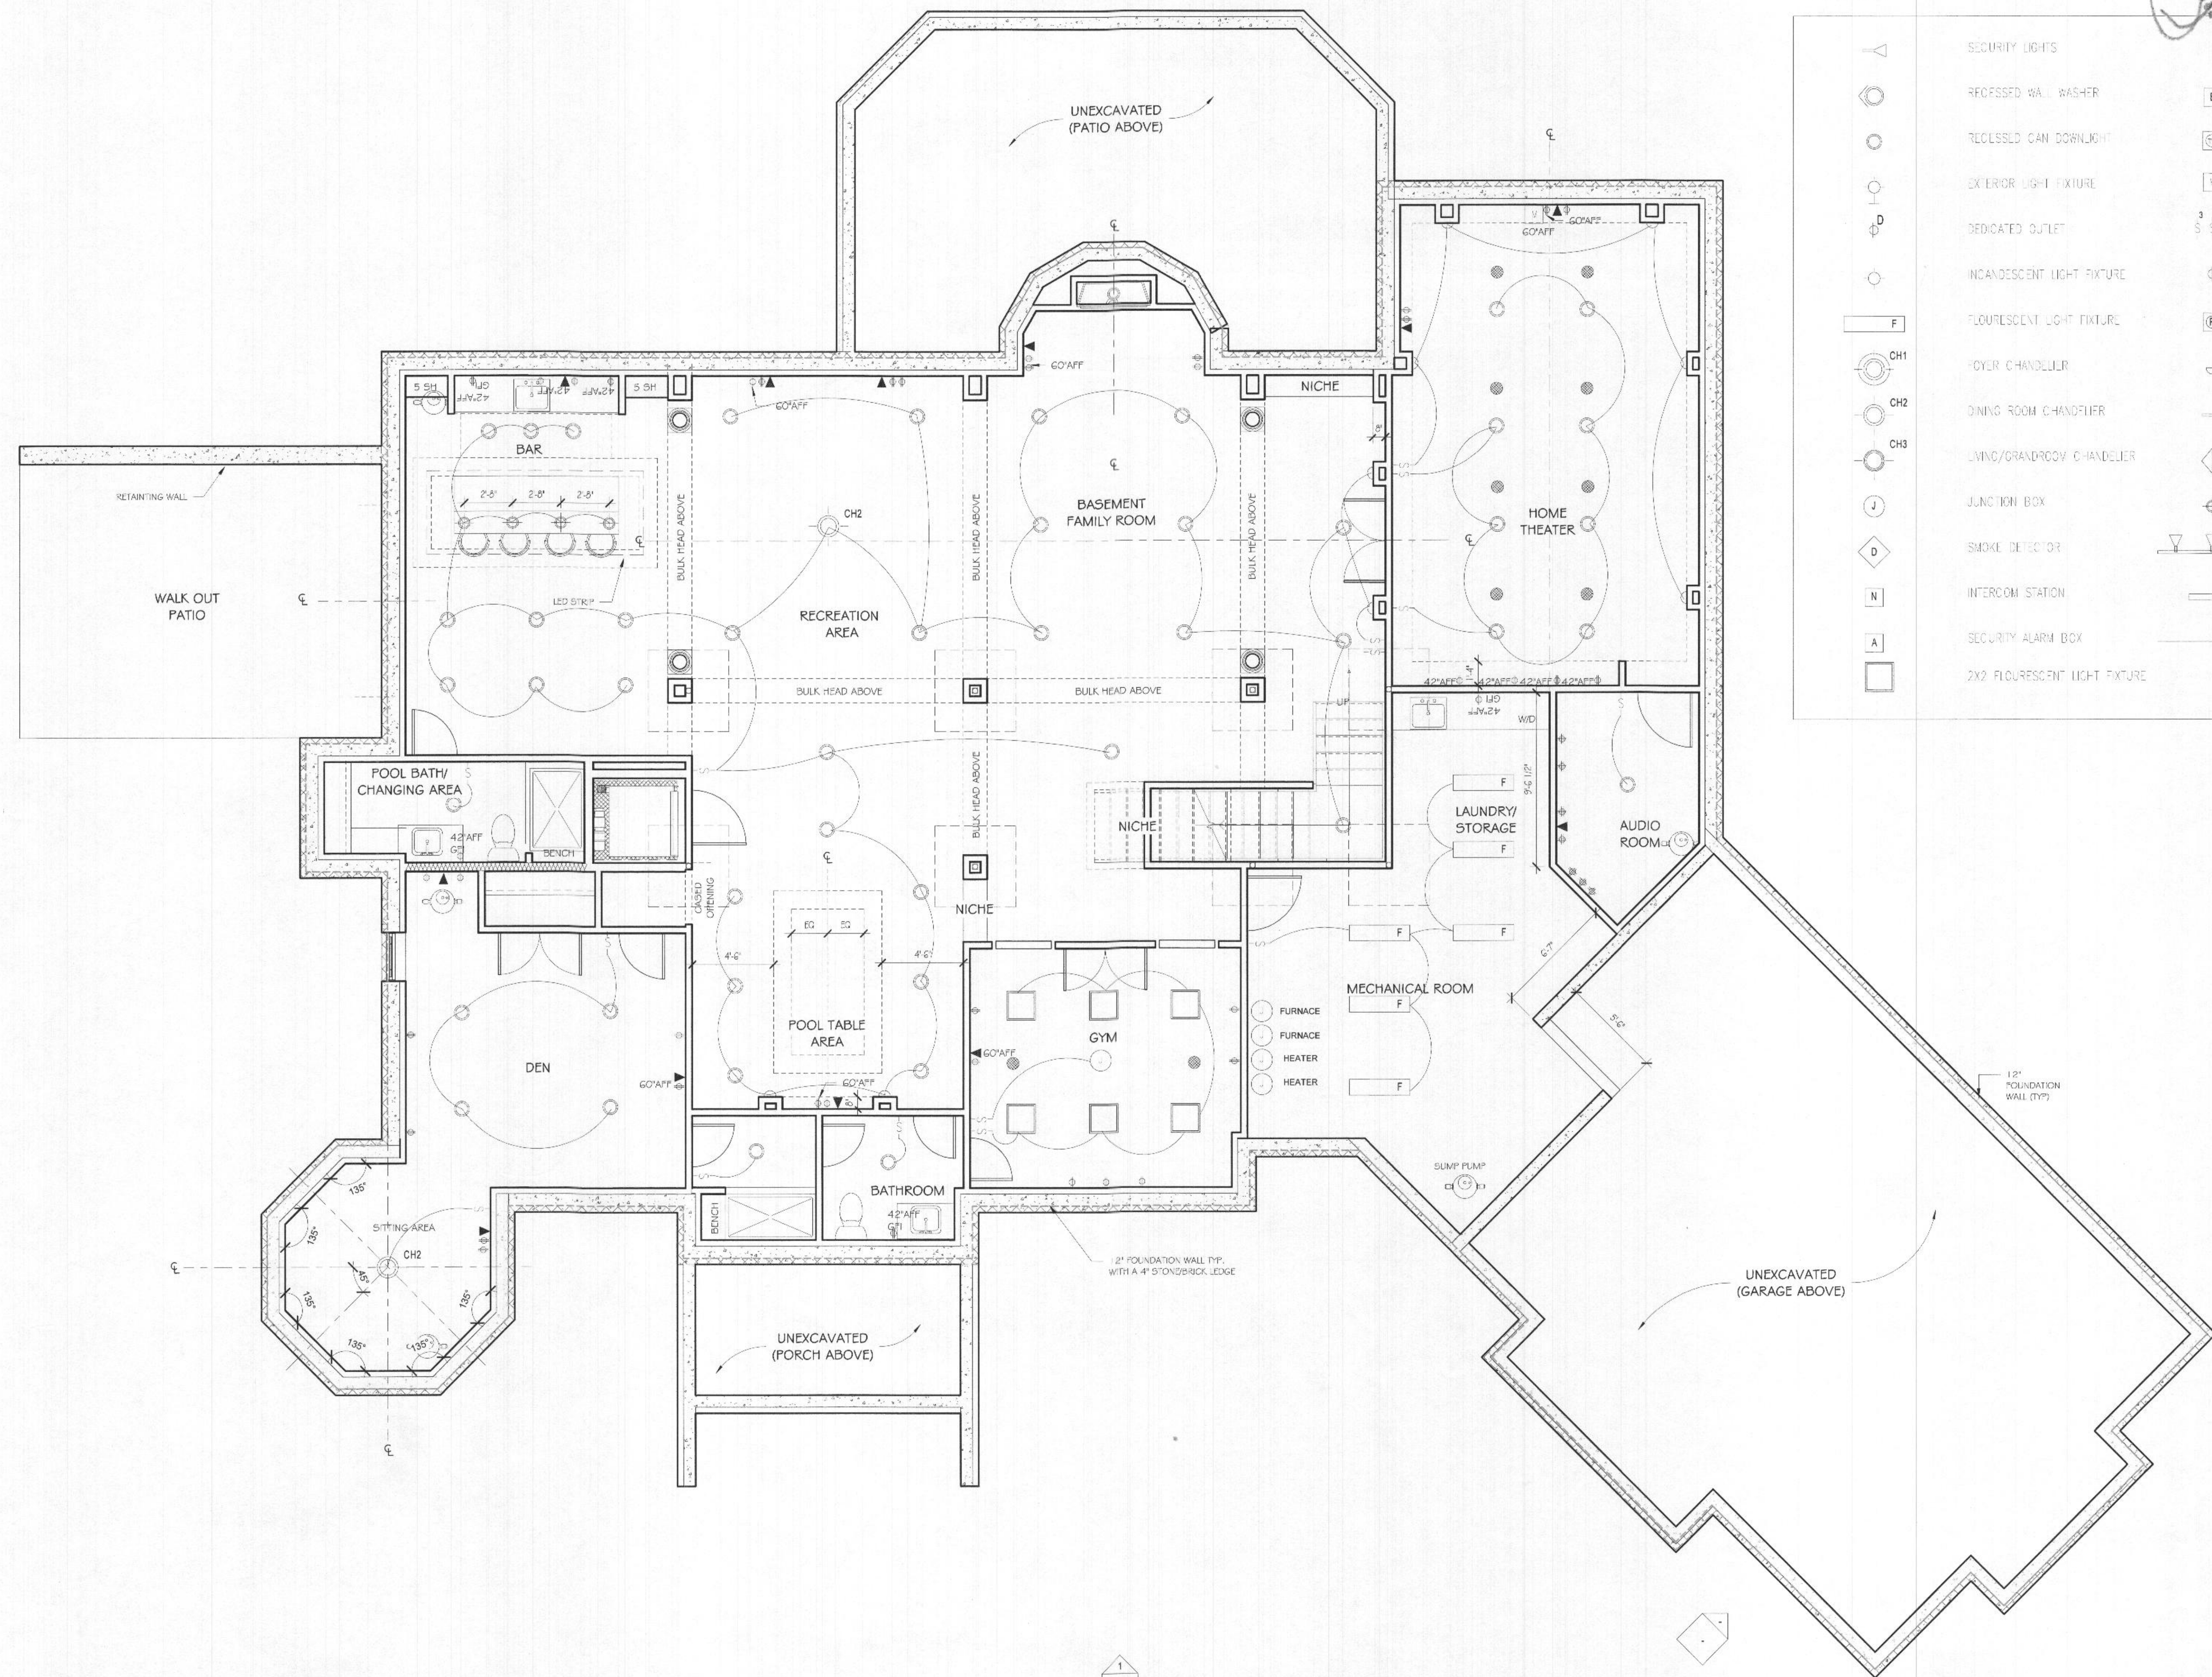

1 BASEMENT ELECTRICAL PLAN  
1/4" = 1'-0"

LEGEND:

|  |                               |  |                             |
|--|-------------------------------|--|-----------------------------|
|  | SECURITY LIGHTS               |  | RECESSED WALL WASHER        |
|  | RECESSED CAN DOWNLIGHT        |  | EXTERIOR LIGHT FIXTURE      |
|  | DEDICATED OUTLET              |  | INCANDESCENT LIGHT FIXTURE  |
|  | FLUORESCENT LIGHT FIXTURE     |  | COYER CHANDELIER            |
|  | DINING ROOM CHANDELIER        |  | LIVING/GRANDROOM CHANDELIER |
|  | JUNCTION BOX                  |  | SMOKE DETECTOR              |
|  | INTERCOM STATION              |  | SECURITY ALARM BOX          |
|  | 2X2 FLUORESCENT LIGHT FIXTURE |  | TELEVISION CABLE OUTLET     |
|  | MULTIMEDIA OUTLET             |  | SWITCH                      |
|  | DUPLEX ELECTRICAL OUTLET      |  | FAN LIGHT                   |
|  | SCONCE                        |  | UNDER CABINET/STEP LIGHTS   |
|  | MONOPOINT LIGHTS              |  | PENDANT LIGHTS              |
|  | TRACK LIGHTS                  |  | VANITY LIGHT                |
|  | LED COVE LIGHT                |  |                             |

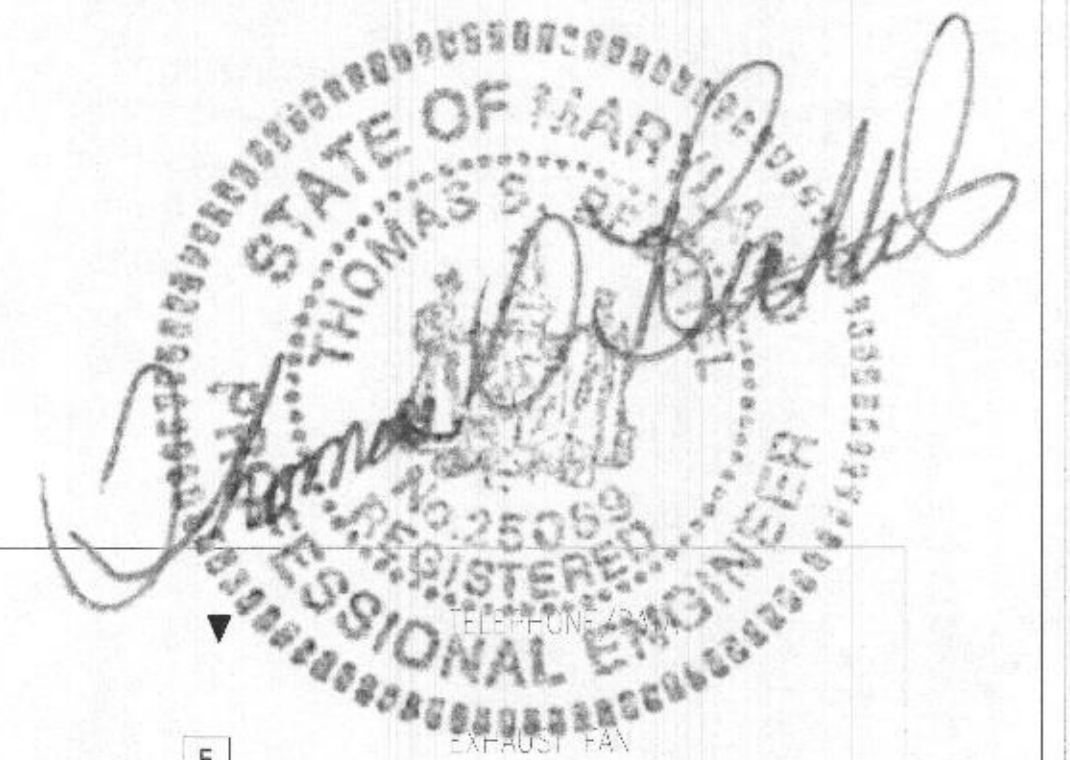

**bethe!**  
Architecture &  
Construction  
Management  
4015 Prince Georges Avenue,  
Suite 204  
Baltimore, Maryland 20705  
Tel: 301.937.7500  
Fax: 301.937.7571

The Design / Drawings remain the property of  
the Architect, Bethe! Design, Construction, Inc.  
Unauthorized reproduction for any purpose is an  
unlawful act and is strictly prohibited. Violators will  
be subject to prosecution by the State of Maryland.  
Written dimensions on these drawings shall  
have precedence over scale dimensions.  
Contractors shall verify and be responsible for  
all dimensions and conditions on the job and this  
office shall be notified of any variation from the  
dimensions and conditions shown by these  
drawings.

8030 KAYLADINE LN, LOT 9 DUSTIN'S GOLDEN FIELDS  
FULTON MD 20759 HOWARD COUNTY  
OGUEJIOFOR RESIDENCE

| Issued | Date     |
|--------|----------|
|        | 08/28/20 |

PROFESSIONAL  
CERTIFICATION

I CERTIFY THAT THESE  
DOCUMENTS WERE PREPARED  
OR APPROVED BY ME, AND  
THAT I AM A QUALIFIED  
ARCHITECT UNDER THE LAWS  
OF THE STATE OF MARYLAND.


LICENSE #:

EXPIRATION:


Permit Stamp

BASEMENT  
ELECTRICAL  
PLAN

E1.0

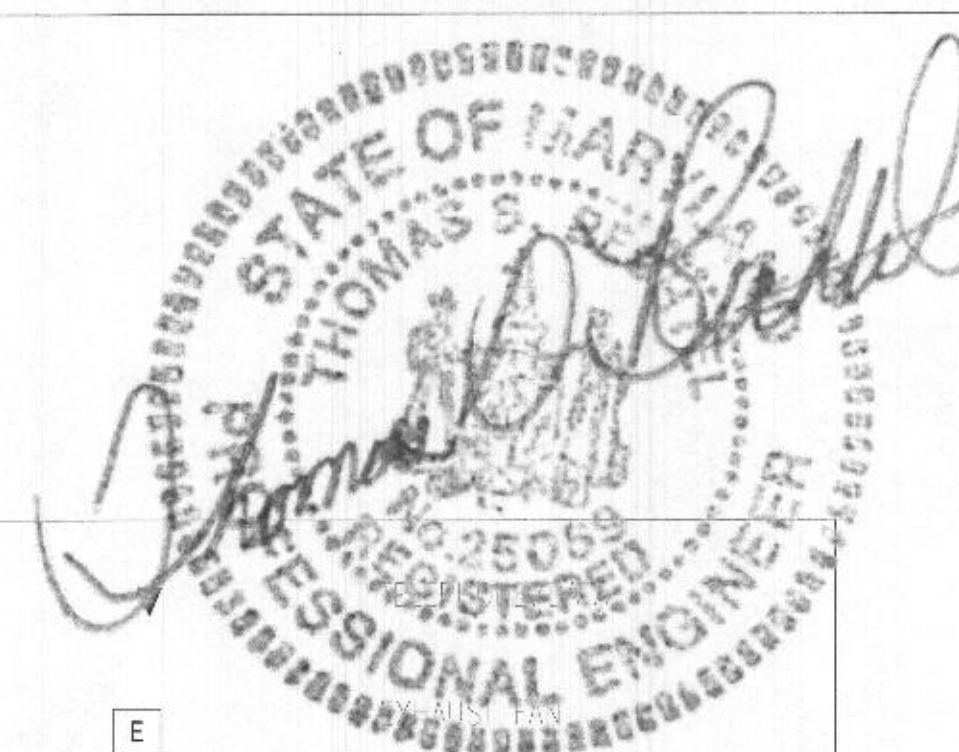


**① FIRST FLOOR ELECTRICAL PLAN**  
**1/4" = 1'-0"**

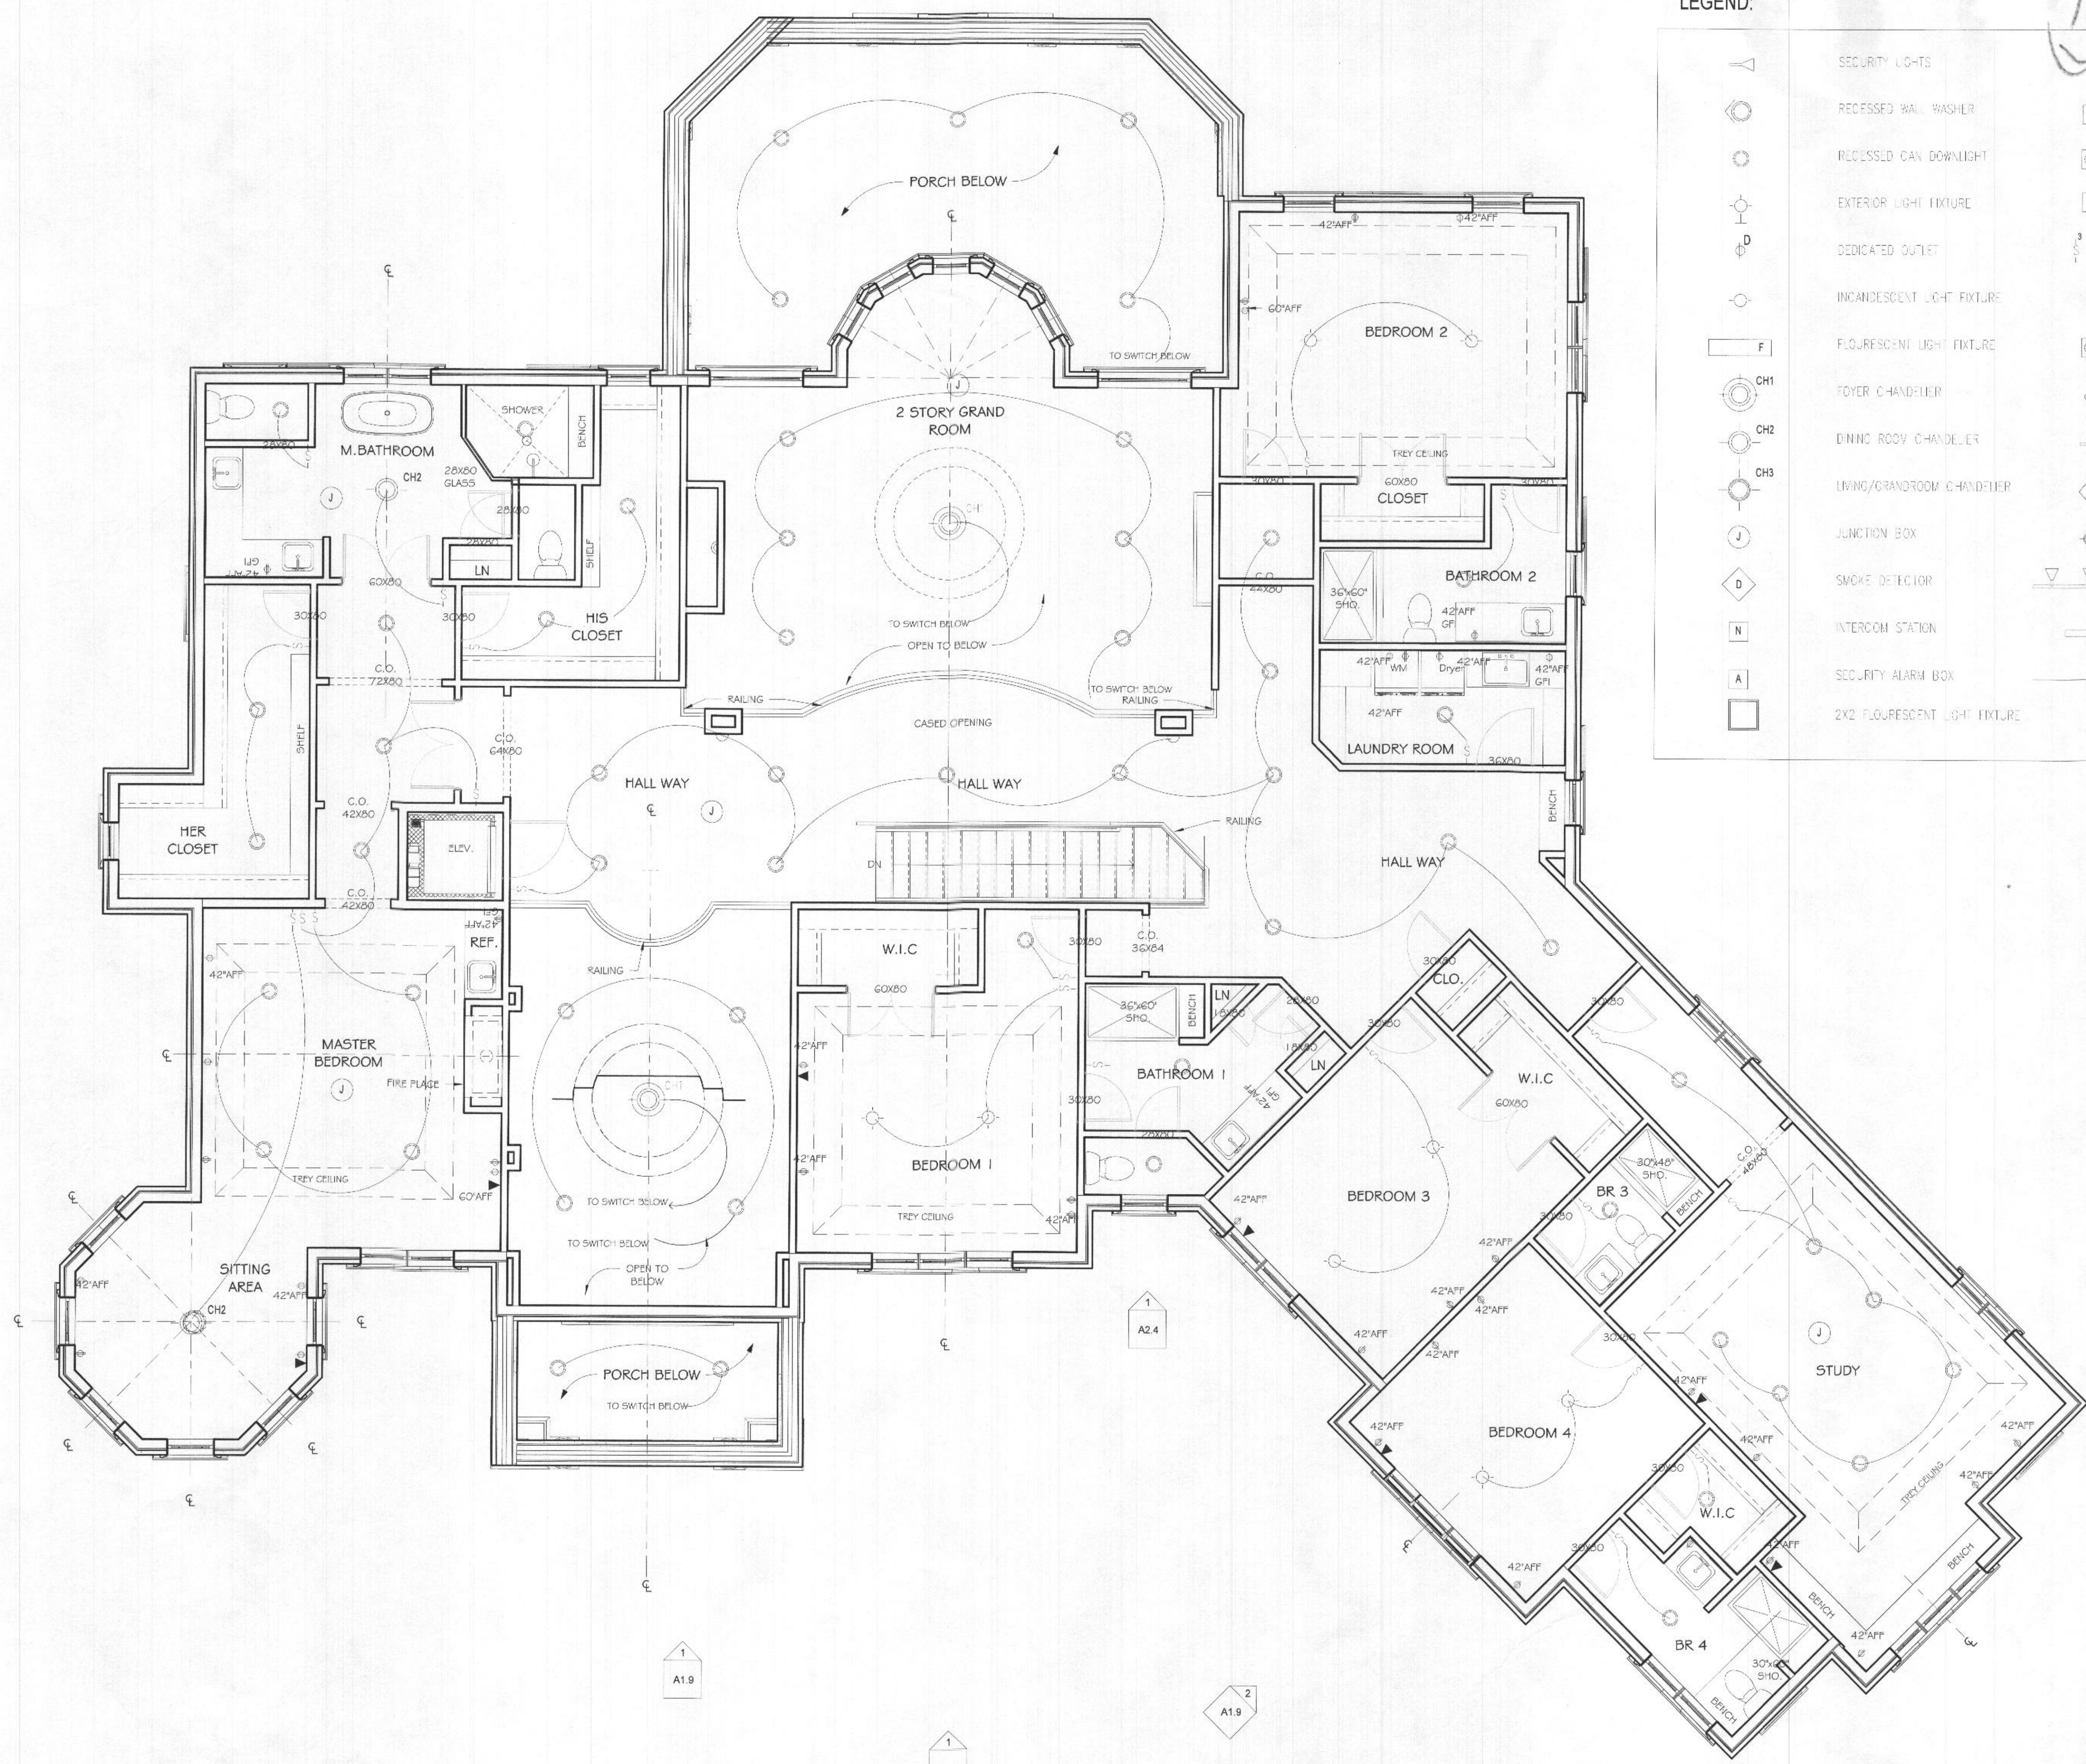

LEGEND:

|  |                               |  |                           |
|--|-------------------------------|--|---------------------------|
|  | SECURITY LIGHTS               |  | TELEVISION CABLE OUTLET   |
|  | RECESSED WALL WASHER          |  | MULTIMEDIA OUTLET         |
|  | RECESSED CAN DOWNLIGHT        |  | SWITCH                    |
|  | EXTERIOR LIGHT FIXTURE        |  | DUPLEX ELECTRICAL OUTLET  |
|  | DEDICATED OUTLET              |  | FAN LIGHT                 |
|  | INCANDESCENT LIGHT FIXTURE    |  | SCENCE                    |
|  | FLUORESCENT LIGHT FIXTURE     |  | UNDER CABINET/STEP LIGHTS |
|  | FOYER CHANDELIER              |  | V.M.P.L. LIGHTS           |
|  | DINING ROOM CHANDELIER        |  | PENDANT LIGHTS            |
|  | LIVING/GRANDROOM CHANDELIER   |  | TRACK LIGHTS              |
|  | JUNCTION BOX                  |  | VANITY LIGHT              |
|  | SMOKE DETECTOR                |  | LED COVE LIGHT            |
|  | INTERCOM STATION              |  |                           |
|  | SECURITY ALARM BOX            |  |                           |
|  | 2X2 FLUORESCENT LIGHT FIXTURE |  |                           |

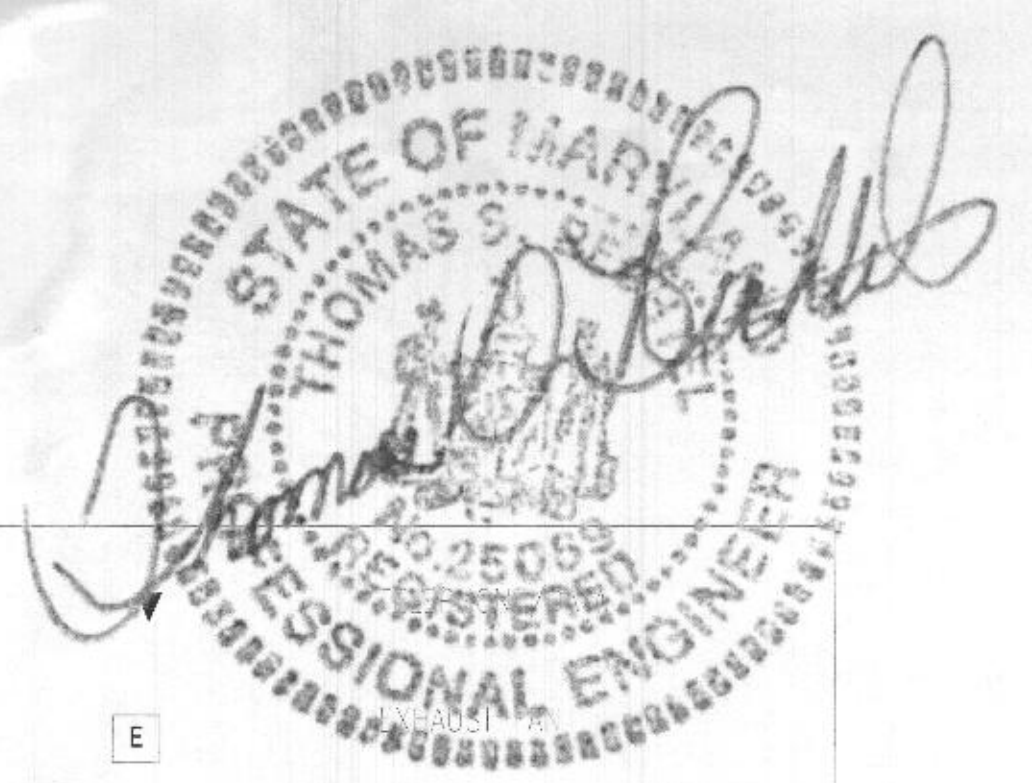

**betnel**  
Architecture & Construction Management, LLC  
4015 Prince Georges Avenue,  
Suite 204  
Beltville, Maryland 20705  
Tel: 301.937.7500  
Fax: 301.637.7571

The Design / Drawings remain the property of the Architect, Betnel Design, Construction, Inc. Unauthorised reproduction for any purpose is an infringement upon copyright law. Violations will be subject to prosecution by the United States of America.

Written dimensions on these drawings shall take precedence over scale dimensions. Contractors shall verify and be responsible for all dimensions and conditions on the job are the office must be notified of any variation from the dimensions and conditions shown by these drawings.

8030 KAYLADINE LN, LOT 9 DUSTIN'S GOLDEN FIELDS  
FULTON MD 20759 HOWARD COUNTY  
OGUEJIOFOR RESIDENCE

| Issued | Date     |
|--------|----------|
|        | 05/25/20 |
|        |          |
|        |          |
|        |          |
|        |          |
|        |          |
|        |          |
|        |          |
|        |          |

PROFESSIONAL CERTIFICATION

I CERTIFY THAT THESE DOCUMENTS WERE PREPARED OR APPROVED BY ME, AND THAT I AM A DULY LICENSED ARCHITECT UNDER THE LAWS OF THE STATE OF MARYLAND.

LICENSE #:

EXPIRATION:

Permit Stamp

**SECOND FLOOR ELECTRICAL PLAN**

E1.2

**1 SECOND FLOOR ELECTRICAL PLAN**  
1/4" = 1'-0"