


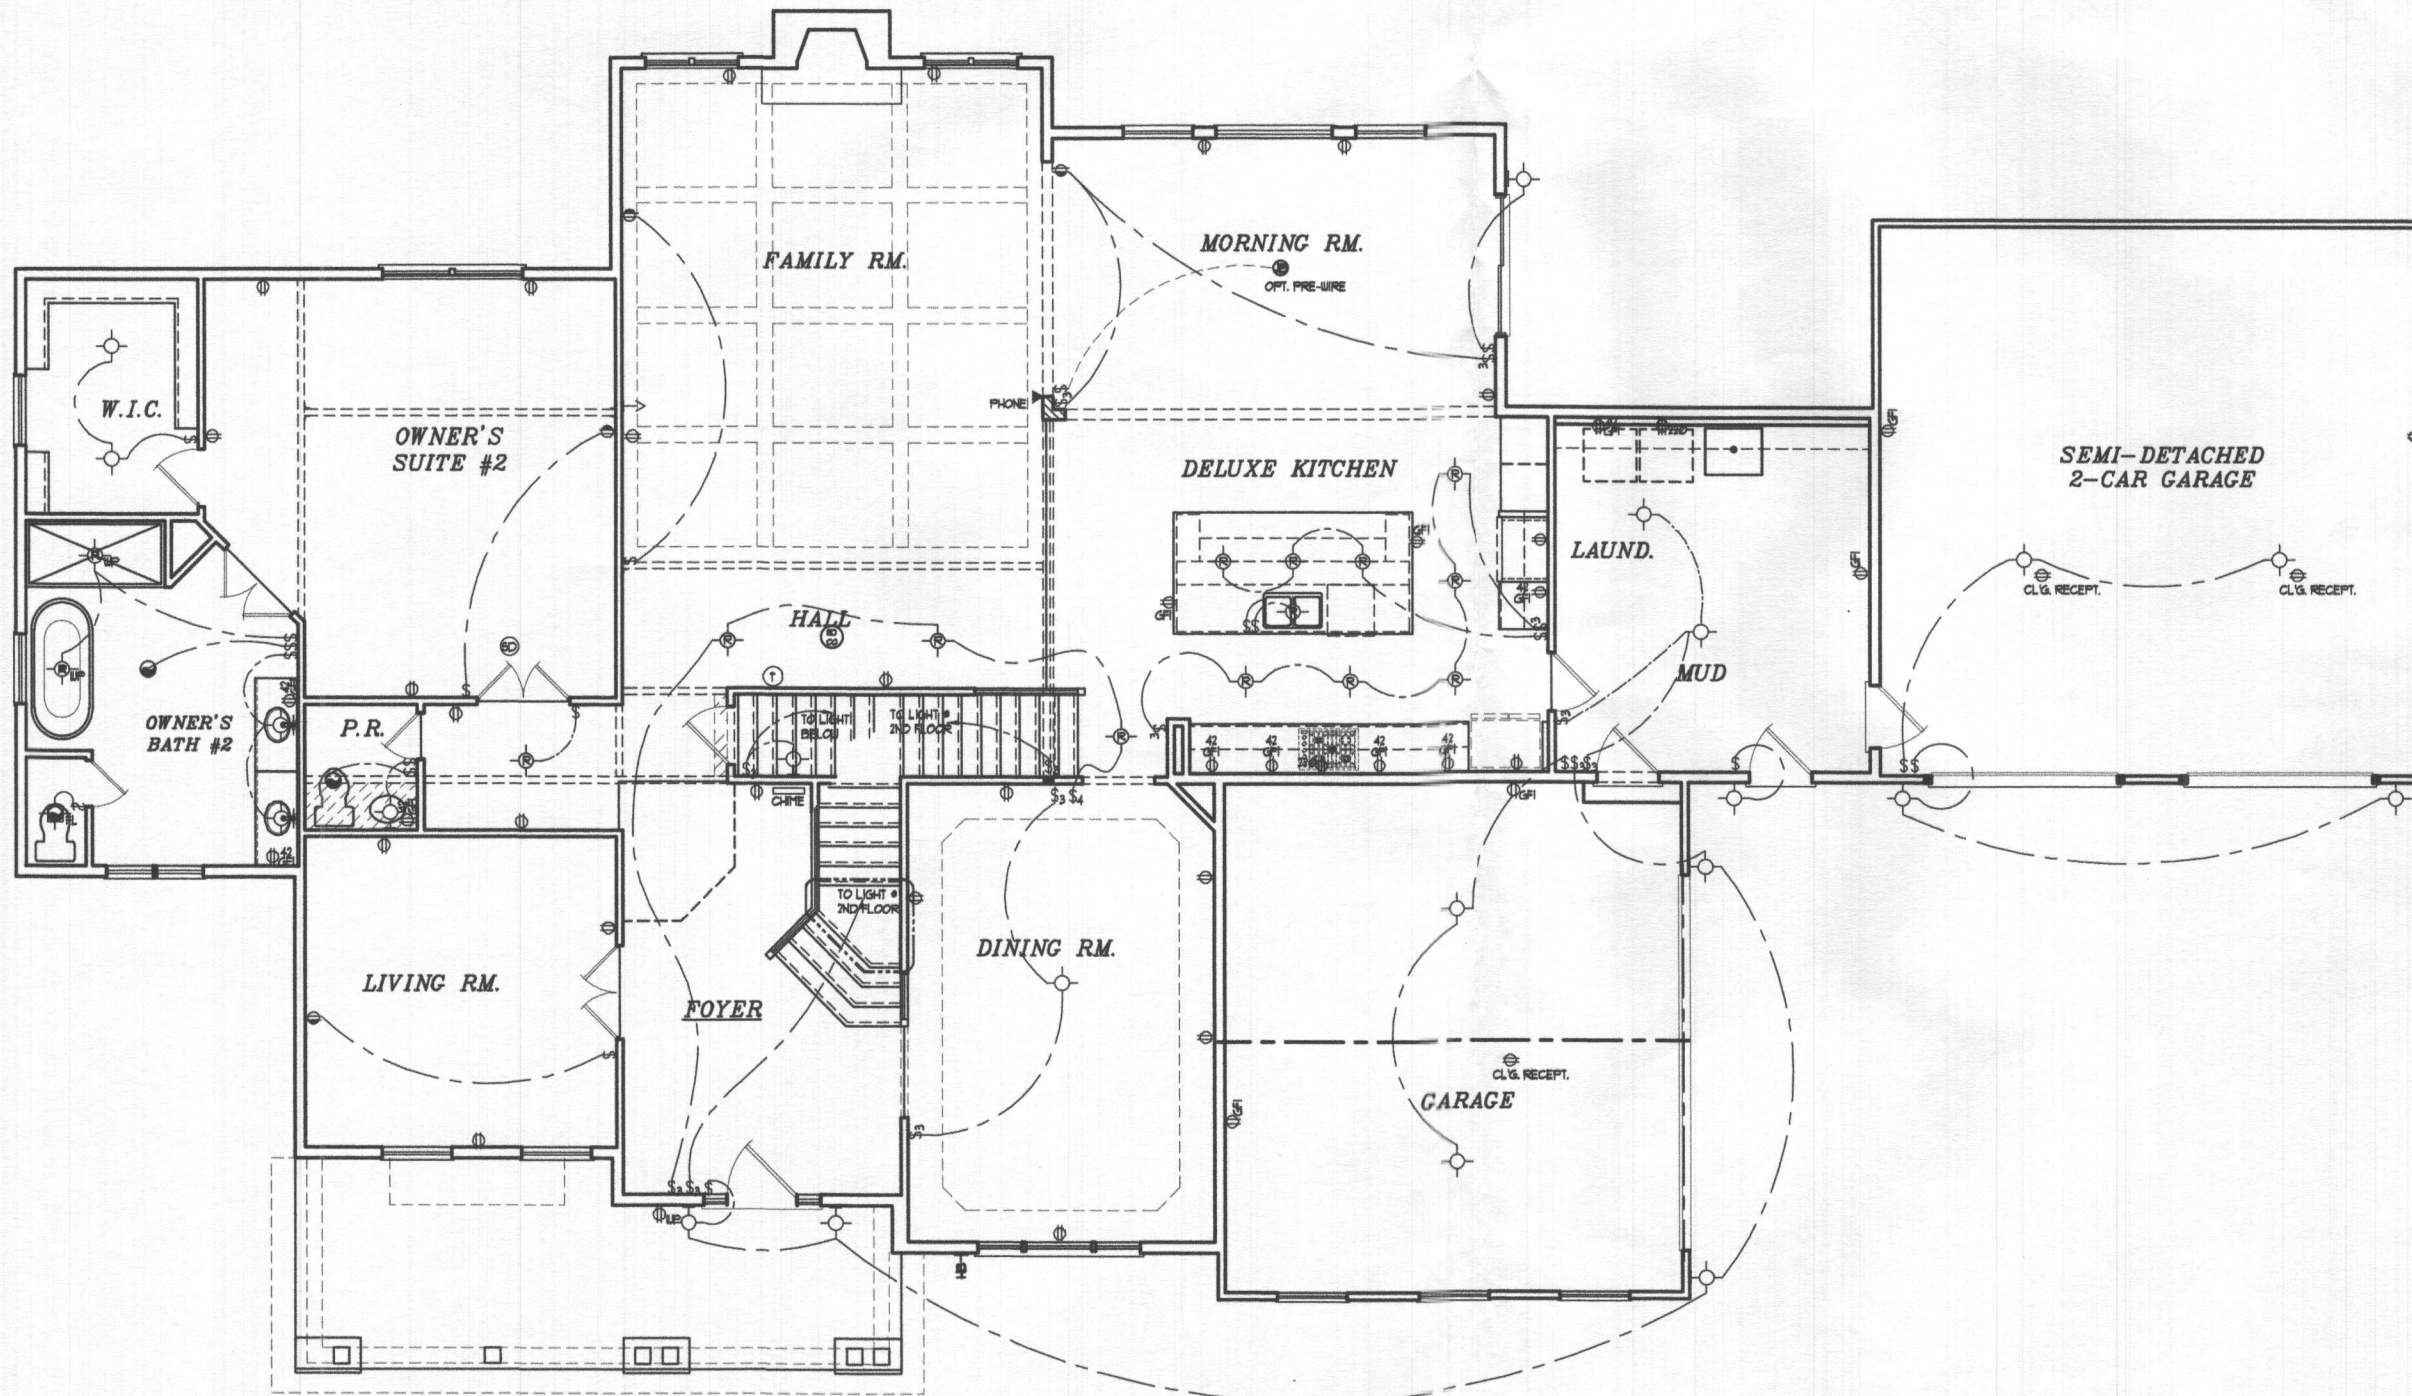

FIRST FLOOR ELECTRIC PLAN
SCALE: 1/4" = 1'-0"

ELECTRICAL NOTES:
CHAPTER 34

- PROVIDE SMOKE DETECTORS AND CARBON MONOXIDE DETECTORS WIRED TO A NEARBY CIRCUIT (WITH BATTERY BACKUP) AND INTER-CONNECTED FOR SIMULTANEOUS ACTIVATION (AS REQUIRED BY CODE).
- ELECTRICAL OUTLETS LOCATED IN GARAGES, KITCHEN, POWDER ROOM, BATH ROOMS, LAUNDRY AREA, CRAWL SPACES AND THE EXTERIOR ARE TO BE GFCI PROTECTED AS REQUIRED BY CODE.
- PROVIDE SWITCH W/ KEYLESS LIGHT IN ATTIC SPACES.
- THESE DRAWINGS ARE SCHEMATIC ONLY.
- THE ELECTRICAL CONTRACTOR IS RESPONSIBLE FOR THE DESIGN AND INSTALLATION OF ALL ELECTRICAL SYSTEMS.
- ALL ELECTRICAL WORK SHALL MEET THE REQUIREMENTS OF THE NATIONAL ELECTRIC CODE, THE LOCAL POWER COMPANY AND ALL APPLICABLE CODES.
- FIXTURES AND APPARATUS ARE SELECTED BY THE BUILDER AND SHALL BE UL APPROVED.

ELECTRICAL SYMBOLS

- DUPLEX OUTLET 15' AFF.
- DUPLEX OUTLET 42' AFF.
- DUPLEX OUTLET 18' AFF. HALF SWITCHED
- 220 VOLT DUPLEX OUTLET
- WATERPROOF RECEPTACLE
- GROUND FAULT INTERRUPTER
- GROUND FAULT INTERRUPTER 42" AFF.
- WALL SWITCH
- 3-WAY WALL SWITCH
- 4-WAY WALL SWITCH
- DIMMER WALL SWITCH
- EXHAUST FAN
- FAN/LIGHT COMBO
- LIGHT FIXTURE CEILING MOUNTED
- LIGHT FIXTURE RECESSED LIGHT
- FIXTURE FULL CHAIN
- FLUORESCENT LIGHT FIXTURE
- FLOOD LIGHTS
- LIGHT FIXTURE WALL MOUNTED
- THERMOSTAT
- JUNCTION BOX
- DOOR CHIME
- TELEPHONE JACK
- TELEVISION JACK
- GARBAGE DISPOSAL
- SMOKE DETECTOR
- CARBON MONOXIDE DETECTOR
- COMBINATION SMOKE - CARBON DETECTOR
- ELECTRIC PANEL
- ELECTRIC METER
- INTERCOM
- INTERCOM CONSOLE


© David R. Robbins expressly reserves his copyright and other property rights in these plans and drawings. These plans and drawings are not to be reproduced in any form or manner without written consent.

Architecture Collaborative, Inc.
8334 Main Street
Ellicott City, MD 21043
www.archcol.com
Tel.: (410) 465-7500 Fax: (410) 465-0903

content FIRST FLOOR ELECTRICAL PLAN
scale: 1" = 4' (34x22) file: 07-12-22
U.N.O. 1" = 8' (17x17) 17.1
drawn: DRW
title: CARUSO HOMES
KINGSPOINT - MD1.0014 SAVOY

date	revision	by

Professional Certification
I hereby certify that these documents were prepared by me, and that I am a duly licensed professional engineer under the laws of the State of Maryland.
license number: 04-08-2023
expiration date: 04-08-2023

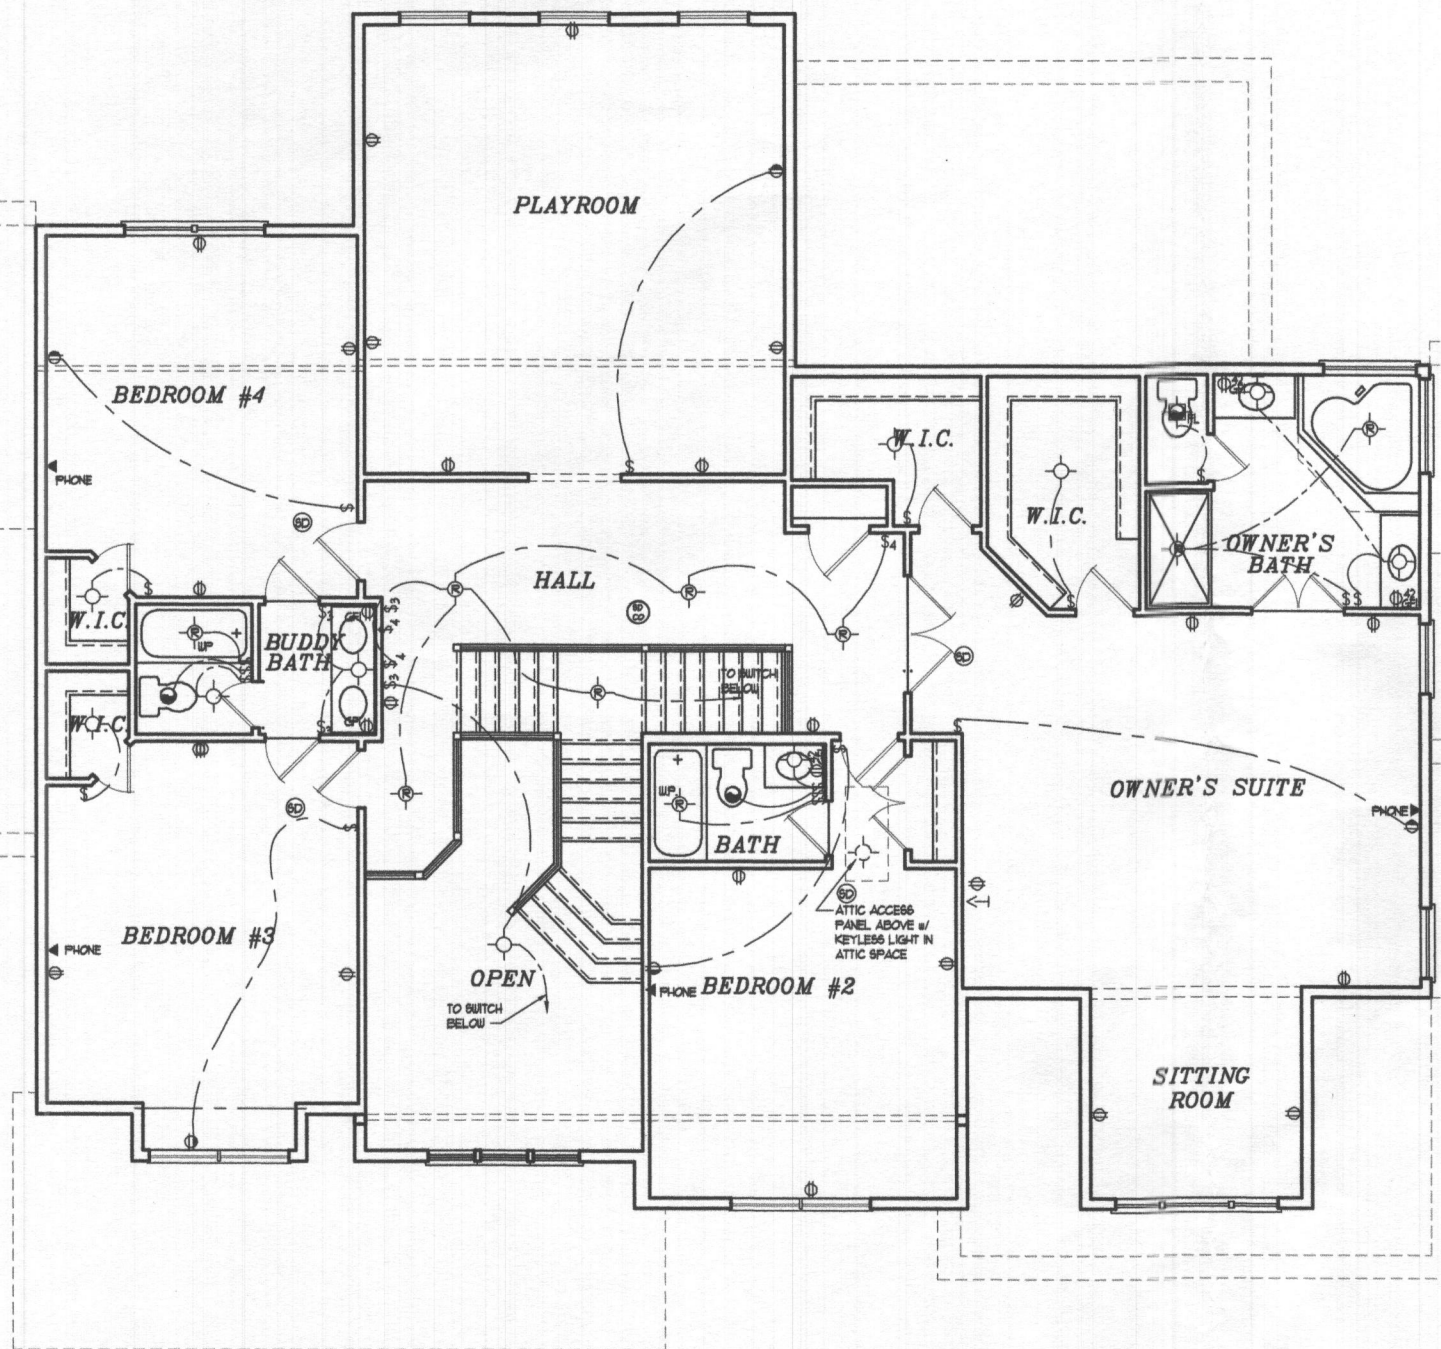

SECOND FLOOR ELECTRIC PLAN
SCALE: 1/8" = 1/4" = 1'-0"

2021 IRC
ELECTRICAL NOTES:
CHAPTER 34

- PROVIDE SMOKE DETECTORS AND CARBON MONOXIDE DETECTORS WIRING TO A NEARBY CIRCUIT (WITH BATTERY BACKUP) AND INTER-CONNECTED FOR SIMULTANEOUS ACTIVATION (AS REQUIRED BY CODE).
- ELECTRICAL OUTLETS LOCATED IN GARAGES, KITCHEN, POWDER ROOM, BATH ROOMS, LAUNDRY AREA, CRAWL SPACES AND THE EXTERIOR ARE TO BE GFCI PROTECTED AS REQUIRED BY CODE.
- PROVIDE SWITCH W/ KEYLESS LIGHT IN ATTIC SPACES.
- THESE DRAWINGS ARE SCHEMATIC ONLY.
- THE ELECTRICAL CONTRACTOR IS RESPONSIBLE FOR THE DESIGN AND INSTALLATION OF ALL ELECTRICAL SYSTEMS.
- ALL ELECTRICAL WORK SHALL MEET THE REQUIREMENTS OF THE NATIONAL ELECTRIC CODE, THE LOCAL POWER COMPANY AND ALL APPLICABLE CODES.
- FIXTURES AND APPARATUS ARE SELECTED BY THE BUILDER AND SHALL BE UL APPROVED.

ELECTRICAL SYMBOLS

- ⊕ DUPLEX OUTLET
- ⊕42 DUPLEX OUTLET 42" AFF.
- ⊕ DUPLEX OUTLET 18" AFF. HALF SWITCHED
- ⊕220 220 VOLT DUPLEX OUTLET
- ⊕P WATERPROOF RECEPTACLE
- ⊕GFI GROUND FAULT INTERRUPTER
- ⊕42 GFI GROUND FAULT INTERRUPTER 42" AFF.
- ⊕S WALL SWITCH
- ⊕3S 3-WAY WALL SWITCH
- ⊕4S 4-WAY WALL SWITCH
- ⊕D DIMMER WALL SWITCH
- ⊕E EXHAUST FAN
- ⊕FL FANLIGHT COMBO
- ⊕L LIGHT FIXTURE CEILING MOUNTED
- ⊕R LIGHT FIXTURE RECESSED LIGHT
- ⊕PC FIXTURE FULL CHAIN FLUORESCENT LIGHT FIXTURE
- ⊕FLOOD FLOOD LIGHTS
- ⊕W LIGHT FIXTURE WALL MOUNTED
- ⊕T THERMOSTAT
- ⊕J JUNCTION BOX
- ⊕C DOOR CHIME
- ⊕TJ TELEPHONE JACK
- ⊕VJ TELEVISION JACK
- ⊕GD GARBAGE DISPOSAL
- ⊕SD SMOKE DETECTOR
- ⊕CD CARBON MONOXIDE DETECTOR
- ⊕SC COMBINATION SMOKE-CARBON DETECTOR
- ⊕EP ELECTRIC PANEL
- ⊕EM ELECTRIC METER
- ⊕I INTERCOM
- ⊕IC INTERCOM CONSOLE

Architecture Collaborative, Inc.
8334 Main Street
Ellicott City, MD 21043
www.archcoll.com
Tel.: (410) 465-7500 Fax: (410) 465-0903

SECOND FLOOR ELECTRICAL PLAN
content: SECOND FLOOR ELECTRICAL PLAN
scale: 1"=4' (34x22) file: U.N.O. 1'-8' (17x11) E2.1
date: 07-12-22
drawn: DRW
title: CARUSO HOMES
KINGSPOINT- MD1.0014 SAVOY

date	revision	by

Professional Certification
I hereby certify that these documents
were prepared or approved by me, and
that I am a duly licensed professional
architect under the laws
of the State of Maryland
license number 0021
expiration date 04-09-2024

SHEET #
E2.1